


FIG. 1 (MD)

KIT LM 625  
WIRING

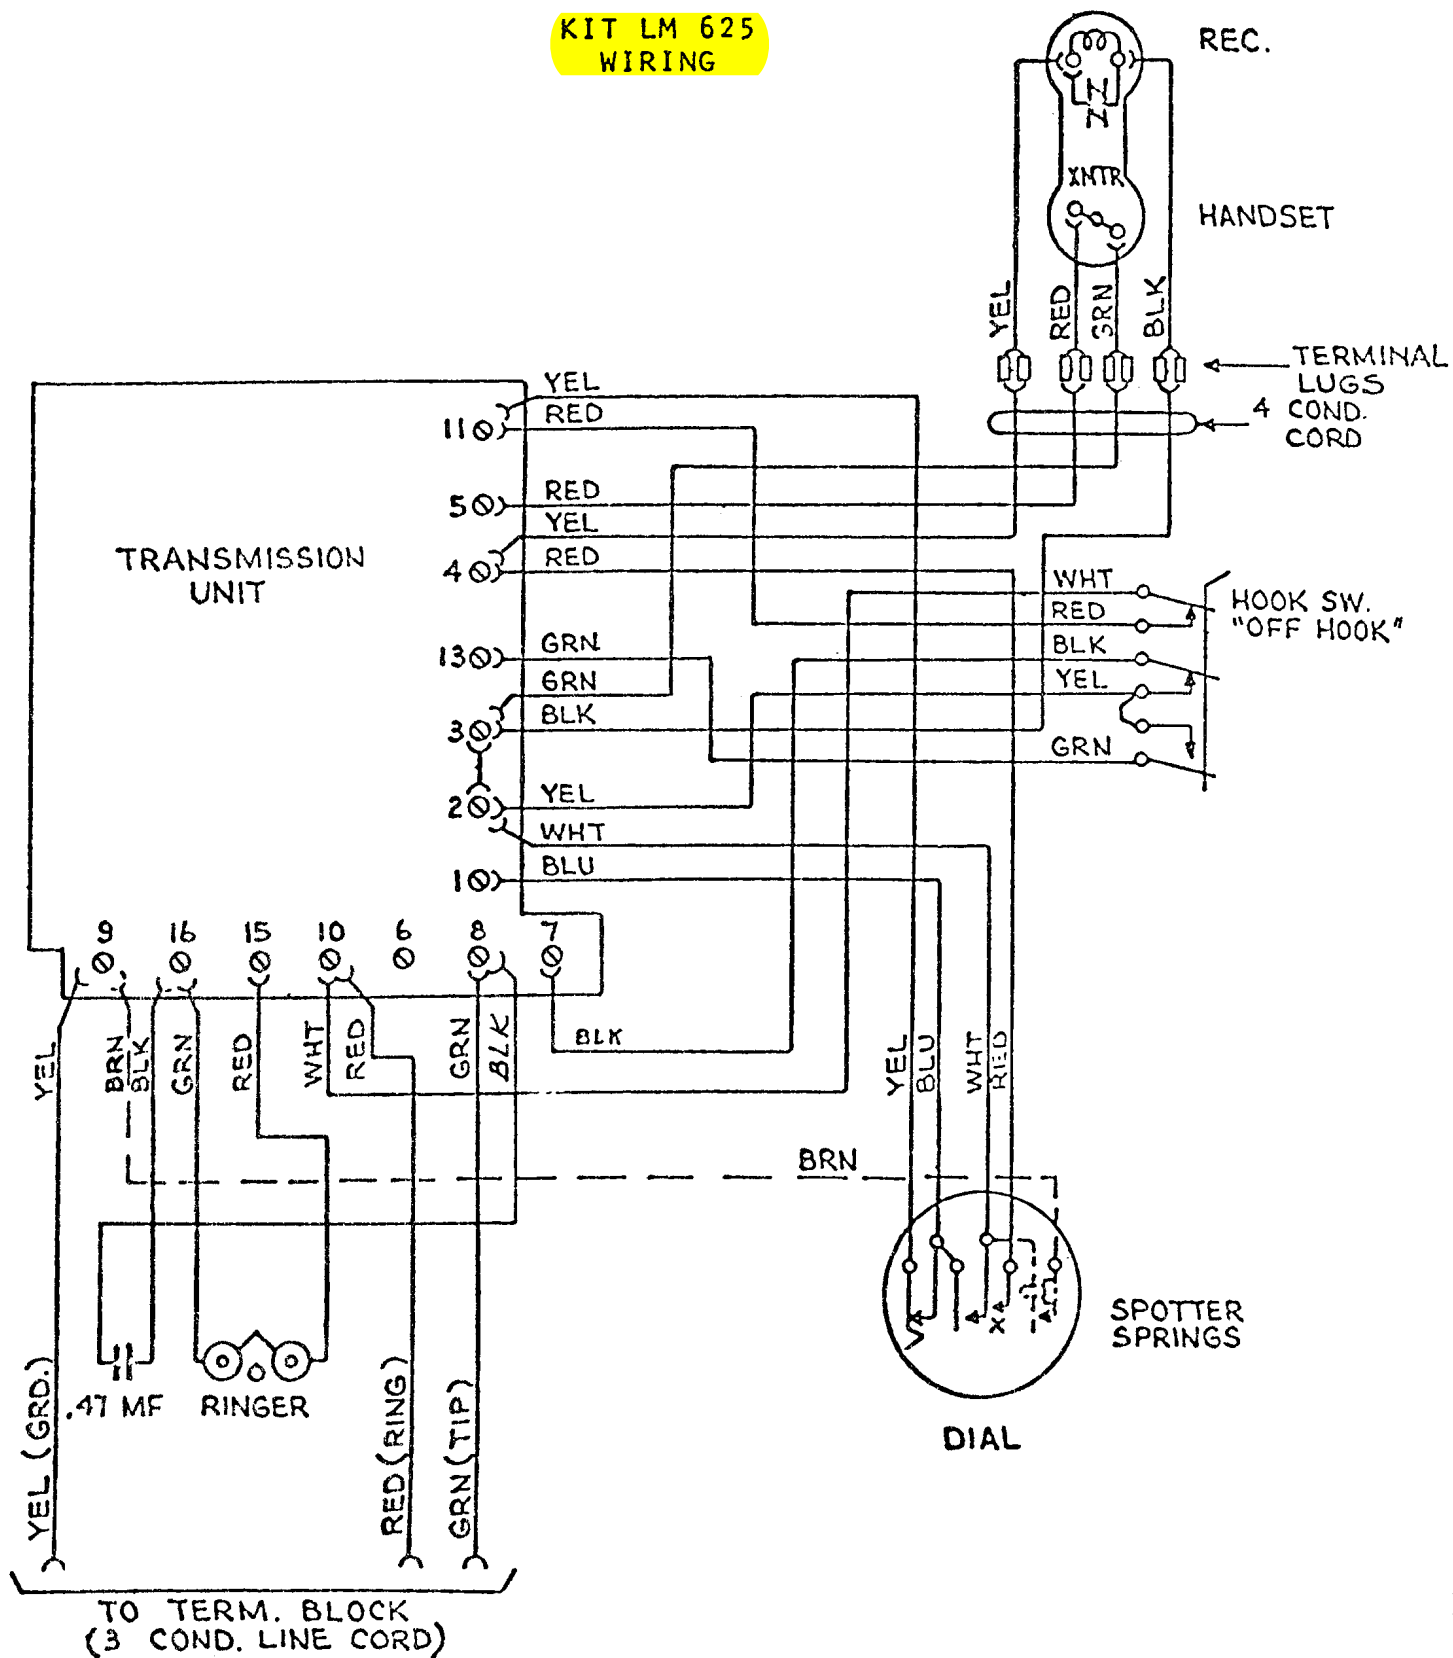


|                            |                     |      |                             |                     |                |
|----------------------------|---------------------|------|-----------------------------|---------------------|----------------|
| FORM NO.<br>ED 0002        | DRAWN BY (Initials) | DATE | TITLE<br>FIG. 1 (MD)        |                     |                |
| FORM SHEET NO.<br>1 (7-73) | APP BY (Initials)   | DATE | DRAWING NO.<br>EPC-2000-FG1 | SHEET NO.<br>1 OF 1 | ISSUE NO.<br>8 |

# GENERAL TELEPHONE OF CALIFORNIA

An Equal Opportunity Employer

THIS DRAWING IS THE PROPERTY OF GENERAL TELEPHONE CO. OF CALIFORNIA. IT IS TO BE KEPT IN THE OFFICE OF THE ENGINEER AND NOT TO BE LOANED, COPIED, REPRODUCED, OR FOR ANY OTHER PURPOSE, WITHOUT WRITTEN PERMISSION FROM GENERAL TELEPHONE CO. OF CALIFORNIA. THIS NOTICE DOES NOT APPLY TO THE U.S. GOVERNMENT TO THE EXTENT THAT IT IS INCONSISTENT WITH ANY CONTRACT WITH THE GOVERNMENT UNDER WHICH THIS DRAWING IS DELIVERED.

FIG. 2  
KIT S.C. 207100-999 WIRING

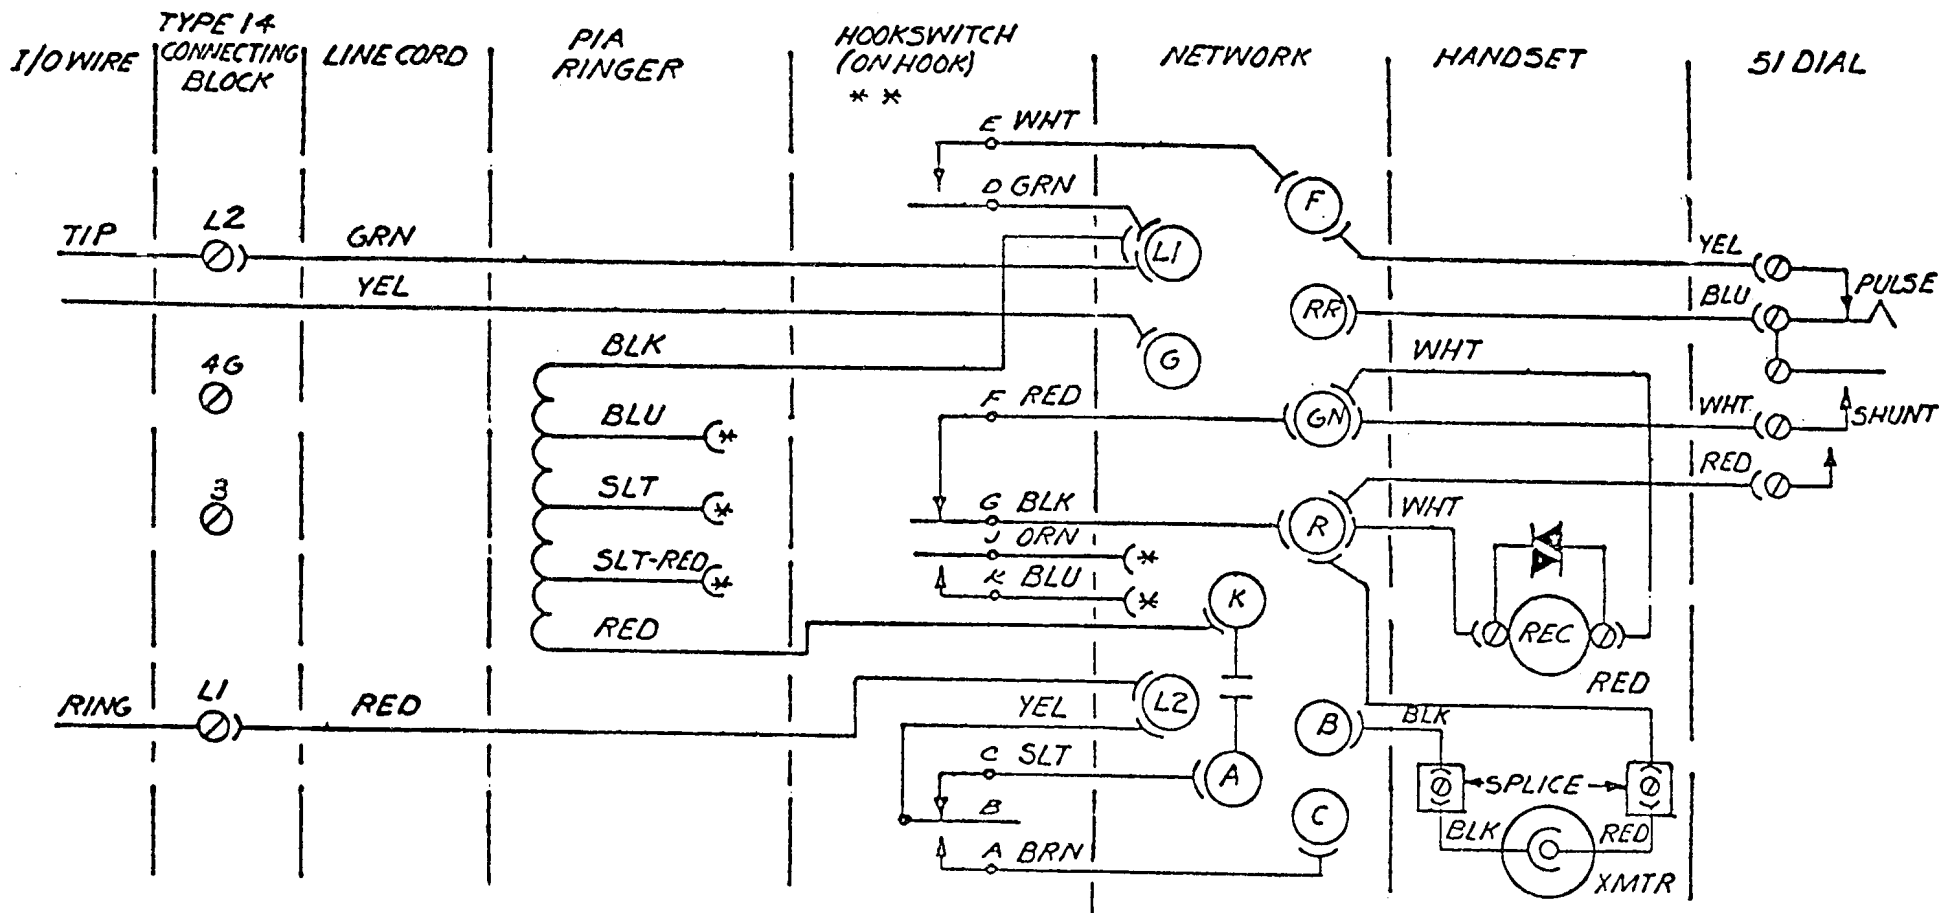

\* INSULATE & STORE

\*\* SEQUENCE OF OPERATION  
WHEN GOING OFF-HOOK:

1. A&B MAKE
2. D&E MAKE, J&K MAKE
3. B&C BREAK
4. F&G BREAK


FIG. 2

TO COPY OR REPRODUCE THE DRAWING IN WHOLE OR IN PART, OR TO USE THE DRAWING TO REPRODUCE THE MATERIAL SHOWN THEREIN, WITHOUT WRITTEN PERMISSION FROM GENERAL TELEPHONE CO. OF CALIFORNIA, THIS NOTICE DOES NOT APPLY TO THE U.S. GOVERNMENT TO THE EXTENT THAT IT IS INCONSISTENT WITH ANY CONTRACT WITH THE GOVERNMENT UNDER WHICH THIS DRAWING IS DELIVERED.

TCI Library- <http://www.telephon collectors.info/>

**GENERAL TELEPHONE OF CALIFORNIA**  
An Equal Opportunity Employer


FIG. 3  
TELEPHONE WITH DIAL LESS RINGER WIRING

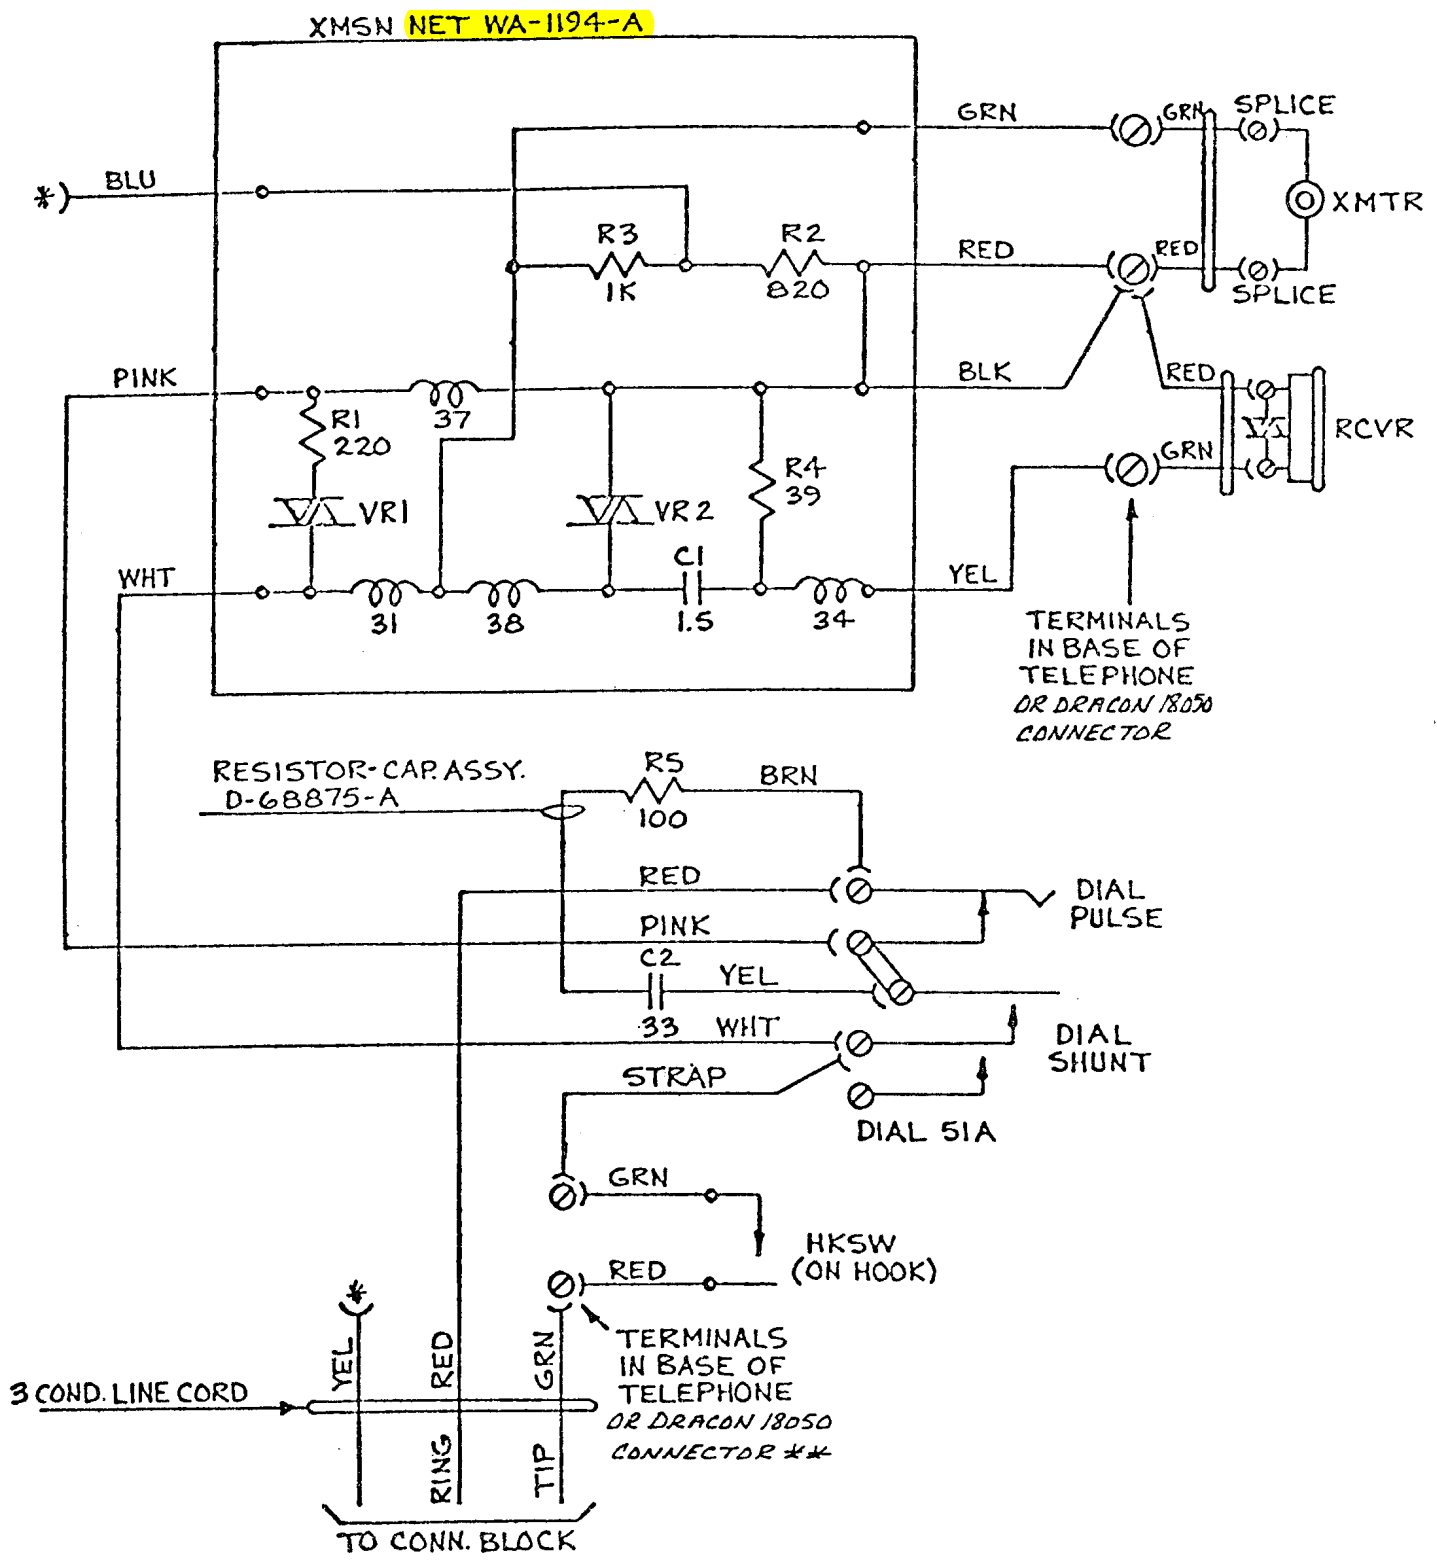

\* INSULATE & STORE  
\*\* IN ORDER TO CONNECT MORE THAN 2 LEADS PER CONNECTOR, TERMINATE 2 LEADS PER SPADE.

|                            |                     |      |                               |
|----------------------------|---------------------|------|-------------------------------|
| FORM NO.<br>ED 0002        | DRAWN BY (Initials) | DATE | TITLE<br>FIG. 3               |
| FORM SHEET NO.<br>1 (7-73) | APP BY (Initials)   | DATE | DRAWING NO.<br>EPC-2000- FG.3 |
|                            |                     |      | SHEET NO.<br>1 OF 1           |
|                            |                     |      | ISSUE NO.<br>3                |

## TELEPHONE LESS DIAL, LESS RINGER WIRING

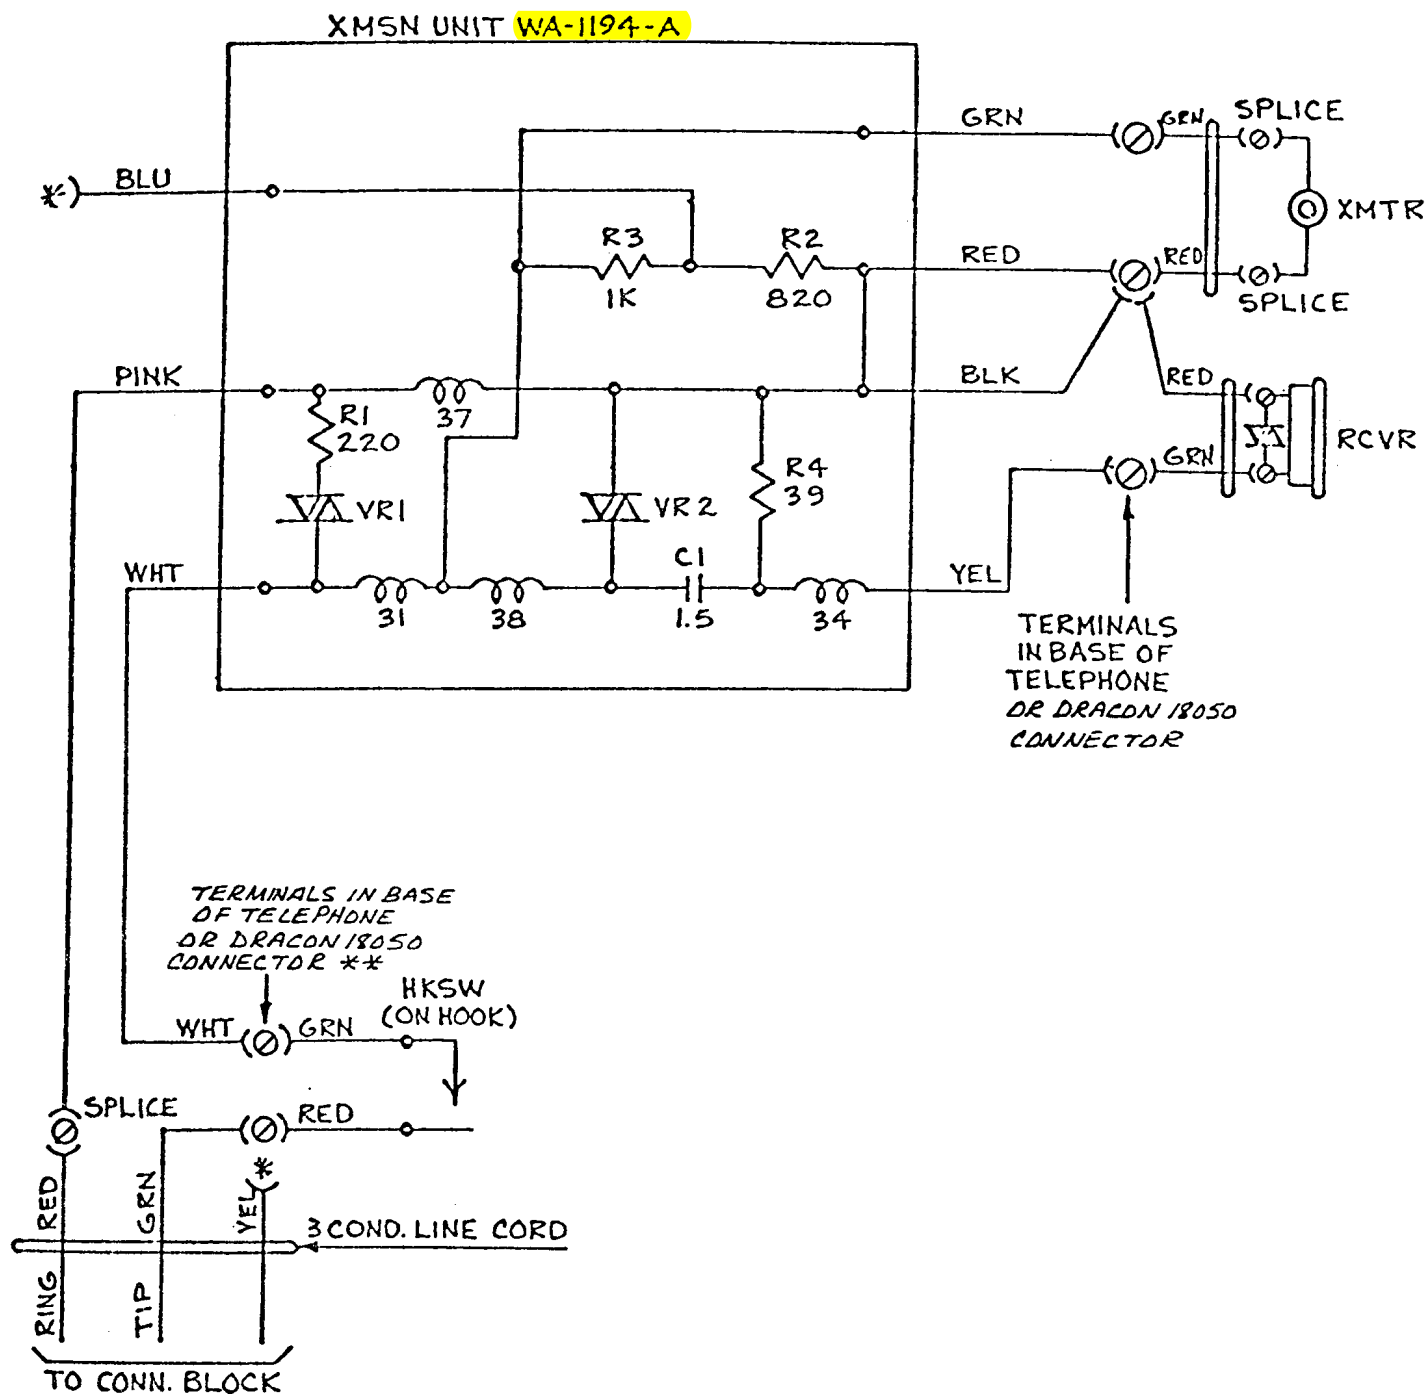


**\*\*INSULATE & STORE**  
**\*\* IN ORDER TO TERMINATE MORE THAN**  
**2 LEADS PER CONNECTOR, TERMINATE**  
**2 LEADS PER SPADE**

|                            |                     |      |                              |                     |                |
|----------------------------|---------------------|------|------------------------------|---------------------|----------------|
| FORM NO.<br>ED 0002        | DRAWN BY (Initials) | DATE | TITLE<br>FIG. 4              |                     |                |
| FORM SHEET NO.<br>1 (7-73) | APP BY (Initials)   | DATE | DRAWING NO.<br>EPC-2000-FG.4 | SHEET NO.<br>1 OF 1 | ISSUE NO.<br>3 |

**An Equal Opportunity Employer**

CANDLESTICK A.T.C./AF WIRING

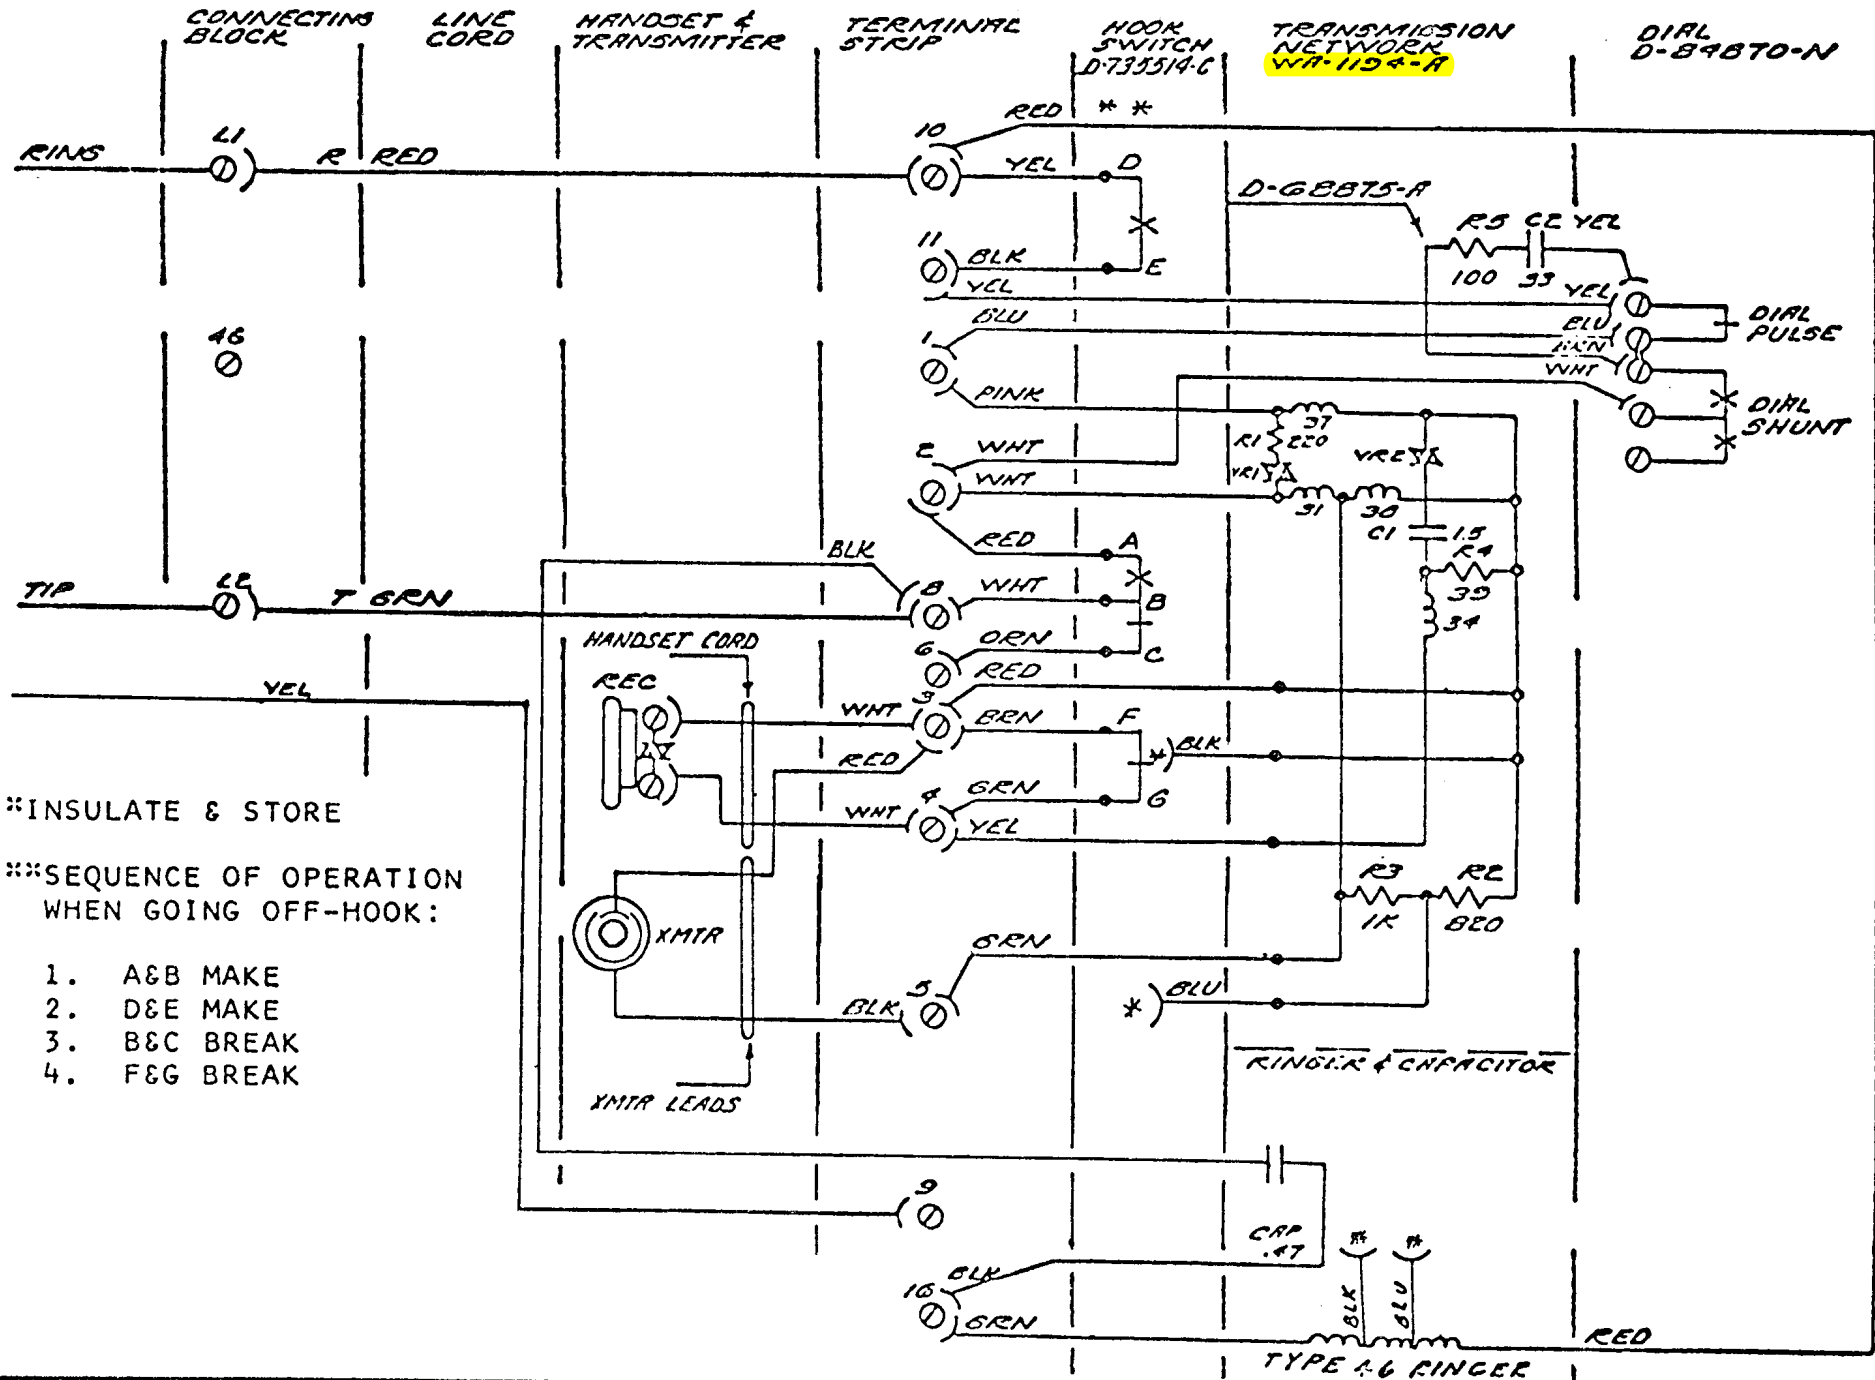

\*INSULATE & STORE

**\*\*SEQUENCE OF OPERATION  
WHEN GOING OFF-HOOK:**

- ```

1.  A&B  MAKE
2.  D&E  MAKE
3.  B&C  BREAK
4.  F&G  BREAK

```

FIG. 5

SHEET NO. 1 OF 1  
ISSUE NO. 8

# GENERAL TELEPHONE OF CALIFORNIA

An Equal Opportunity Employer

FIG. 6

## CANDLESTICK A.T.C./AE WIRING (A. & A1 CONTROL)


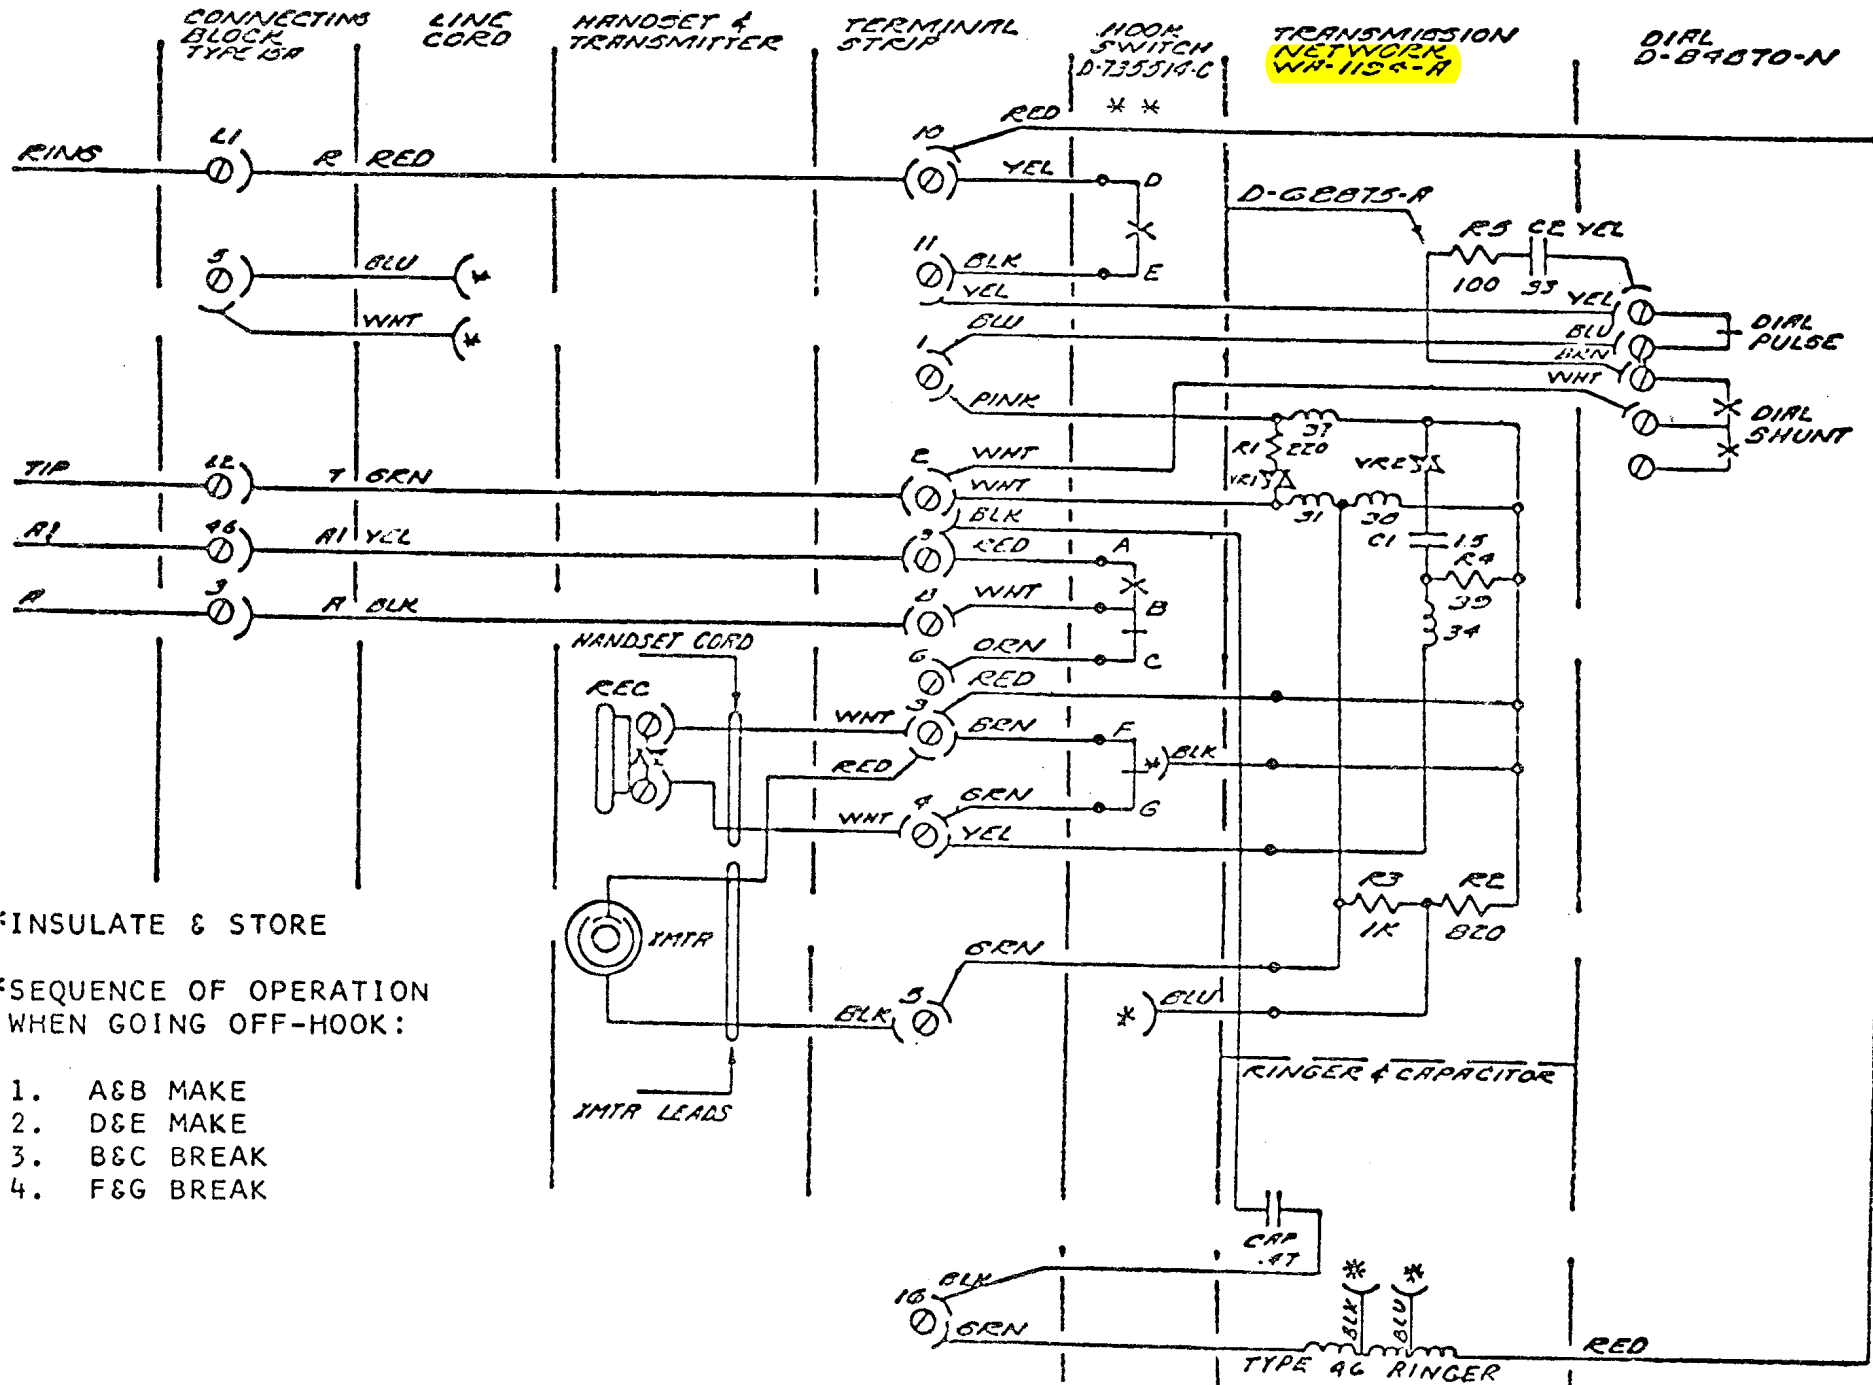


FIG. 6

THIS DRAWING IS THE PROPERTY OF THE U.S. GOVERNMENT. IT IS TO BE USED FOR THE PURPOSES FOR WHICH IT WAS PREPARED AND NOT TO BE REPRODUCED OR TRANSMITTED IN ANY FORM OR BY ANY MEANS, ELECTRONIC OR MECHANICAL, INCLUDING PHOTOCOPYING, RECORDING, OR BY ANY INFORMATION STORAGE AND RETRIEVAL SYSTEM, WITHOUT PERMISSION IN WRITING FROM THE U.S. GOVERNMENT. THIS NOTICE DOES NOT APPLY TO THE U.S. GOVERNMENT TO THE EXTENT THAT IT IS INCONSISTENT WITH ANY CONTRACT WITH THE GOVERNMENT UNDER WHICH THIS DRAWING IS DELIVERED.


FIG. 7 (MD)  
**TELEPHONE WIRING LESS DIAL W/RINGER**

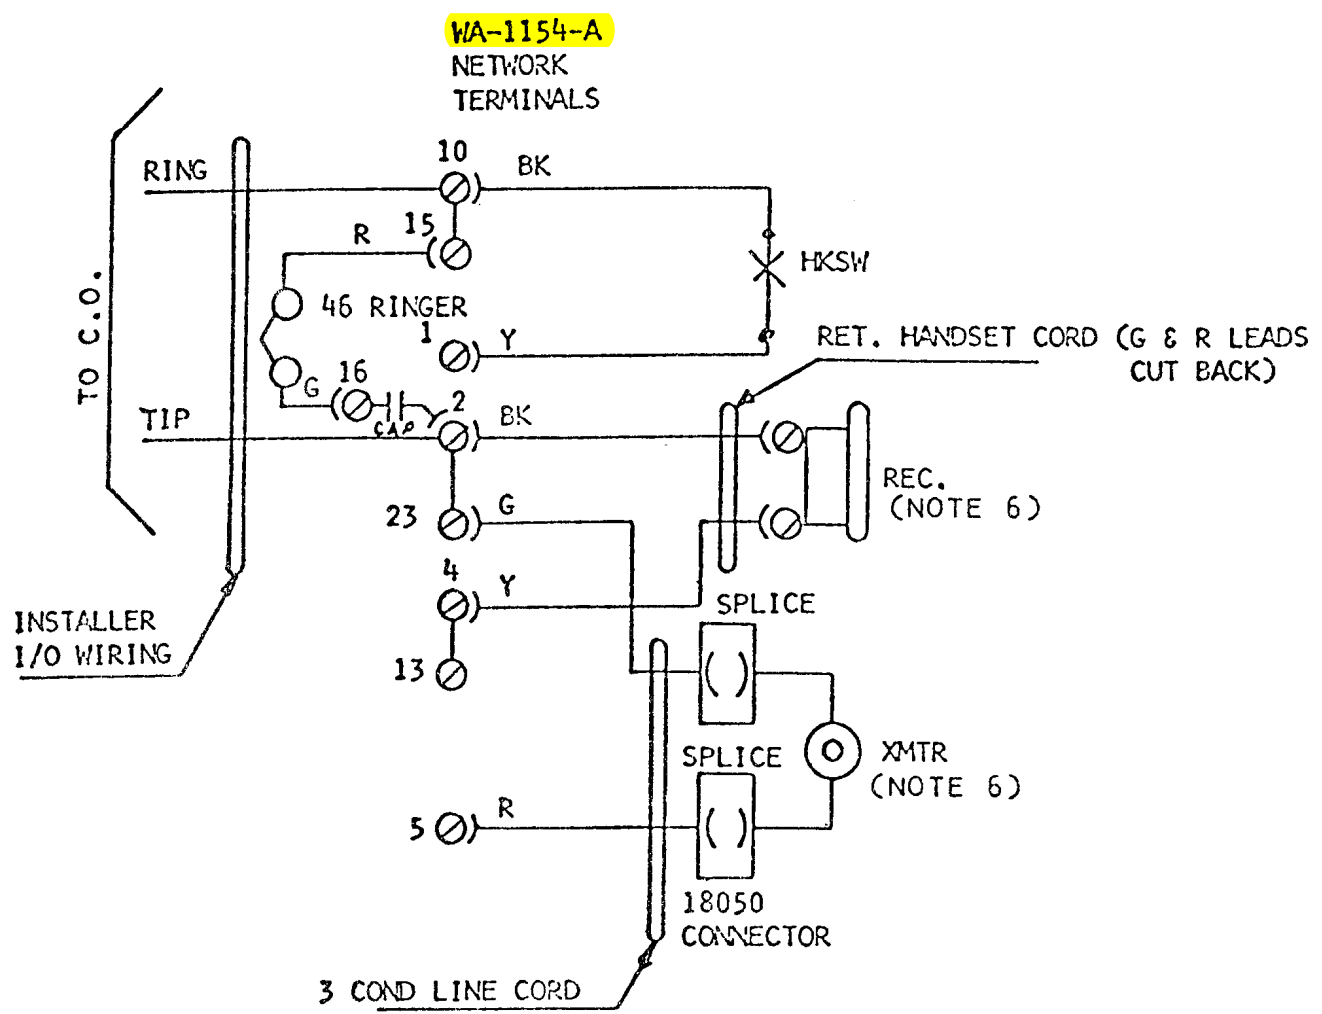

|                            |                     |                |                               |
|----------------------------|---------------------|----------------|-------------------------------|
| FORM NO.<br>ED 0002        | DRAWN BY (Initials) | DATE           | TITLE<br>FIG. 7               |
| FORM SHEET NO.<br>1 (7-73) | APP BY (Initials)   | DATE           | DRAWING NO.<br>EPC-2000- FG.7 |
| SHEET NO.<br>1 OF 1        |                     | ISSUE NO.<br>2 |                               |


THIS DRAWING IS THE PROPERTY OF THE U.S. GOVERNMENT. IT IS TO BE USED FOR THE PURPOSES FOR WHICH IT WAS PREPARED AND NOT BE REPRODUCED OR TRANSMITTED IN ANY FORM OR BY ANY MEANS, ELECTRONIC OR MECHANICAL, INCLUDING PHOTOCOPYING, RECORDING, OR BY ANY INFORMATION STORAGE AND RETRIEVAL SYSTEM, WITHOUT PERMISSION IN WRITING FROM THE U.S. GOVERNMENT. THIS NOTICE DOES NOT APPLY TO ANY OTHER PURPOSES.

**FIG. 8 (MD)**  
**TELEPHONE WIRING E/W DIAL & RINGER**

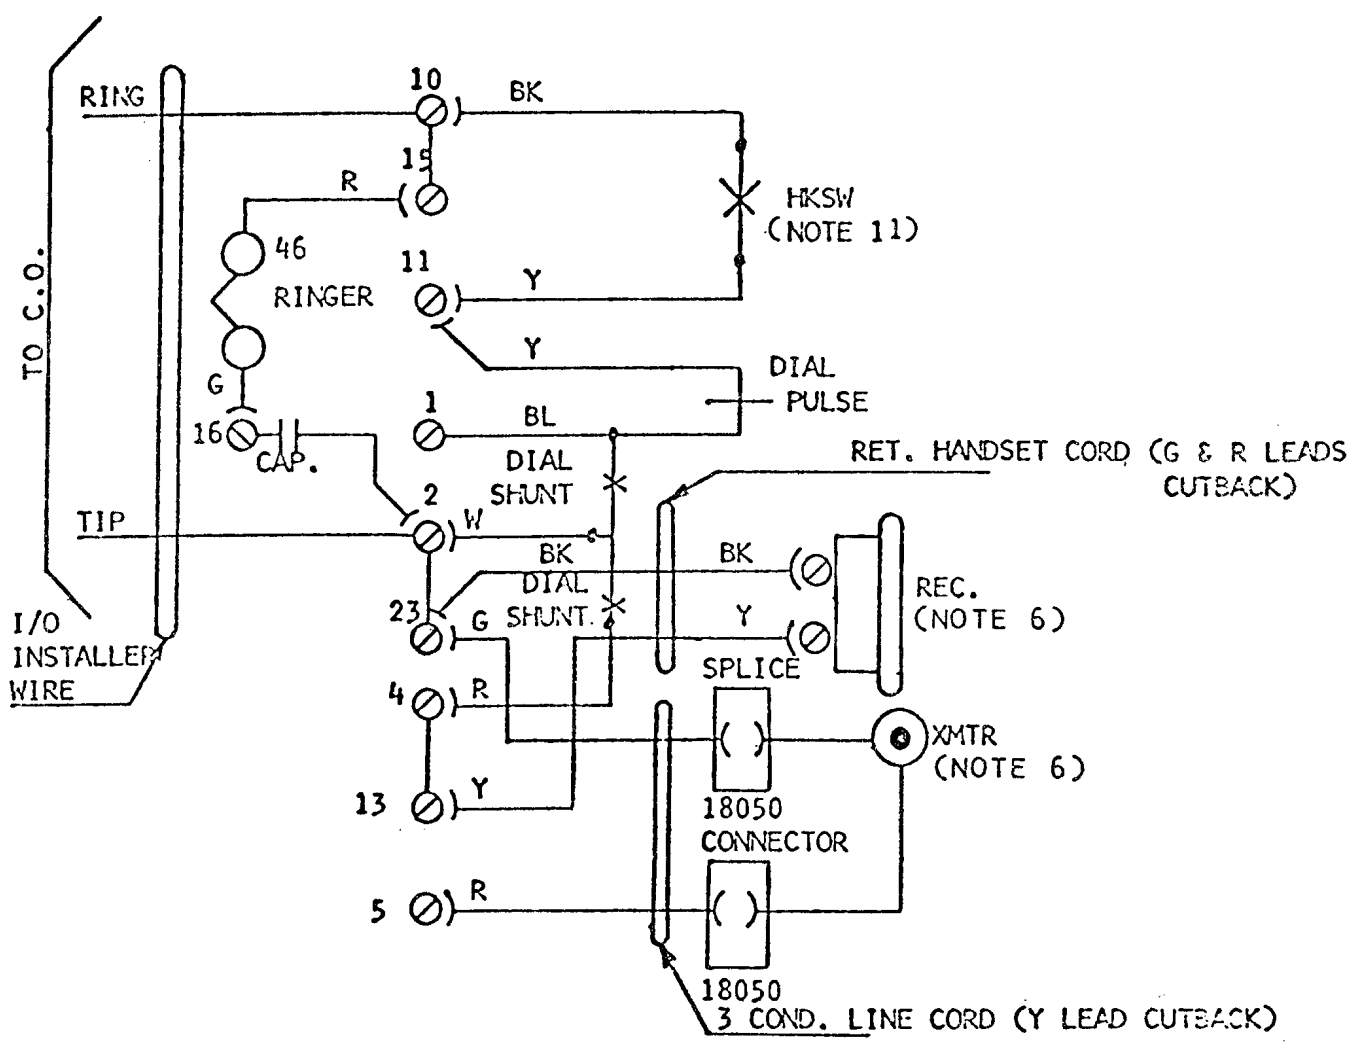

|                            |                     |      |                               |                     |                |
|----------------------------|---------------------|------|-------------------------------|---------------------|----------------|
| FORM NO.<br>ED 0002        | DRAWN BY (Initials) | DATE | TITLE<br>FIG. 8               |                     |                |
| FORM SHEET NO.<br>1 (7-73) | APP BY (Initials)   | DATE | DRAWING NO.<br>EPC-2000- FG.8 | SHEET NO.<br>1 OF 1 | ISSUE NO.<br>8 |

FIG. 9  
MODEL ZBSA 24 21021 (GERMAN)  
W/DIAL & LESS RINGER

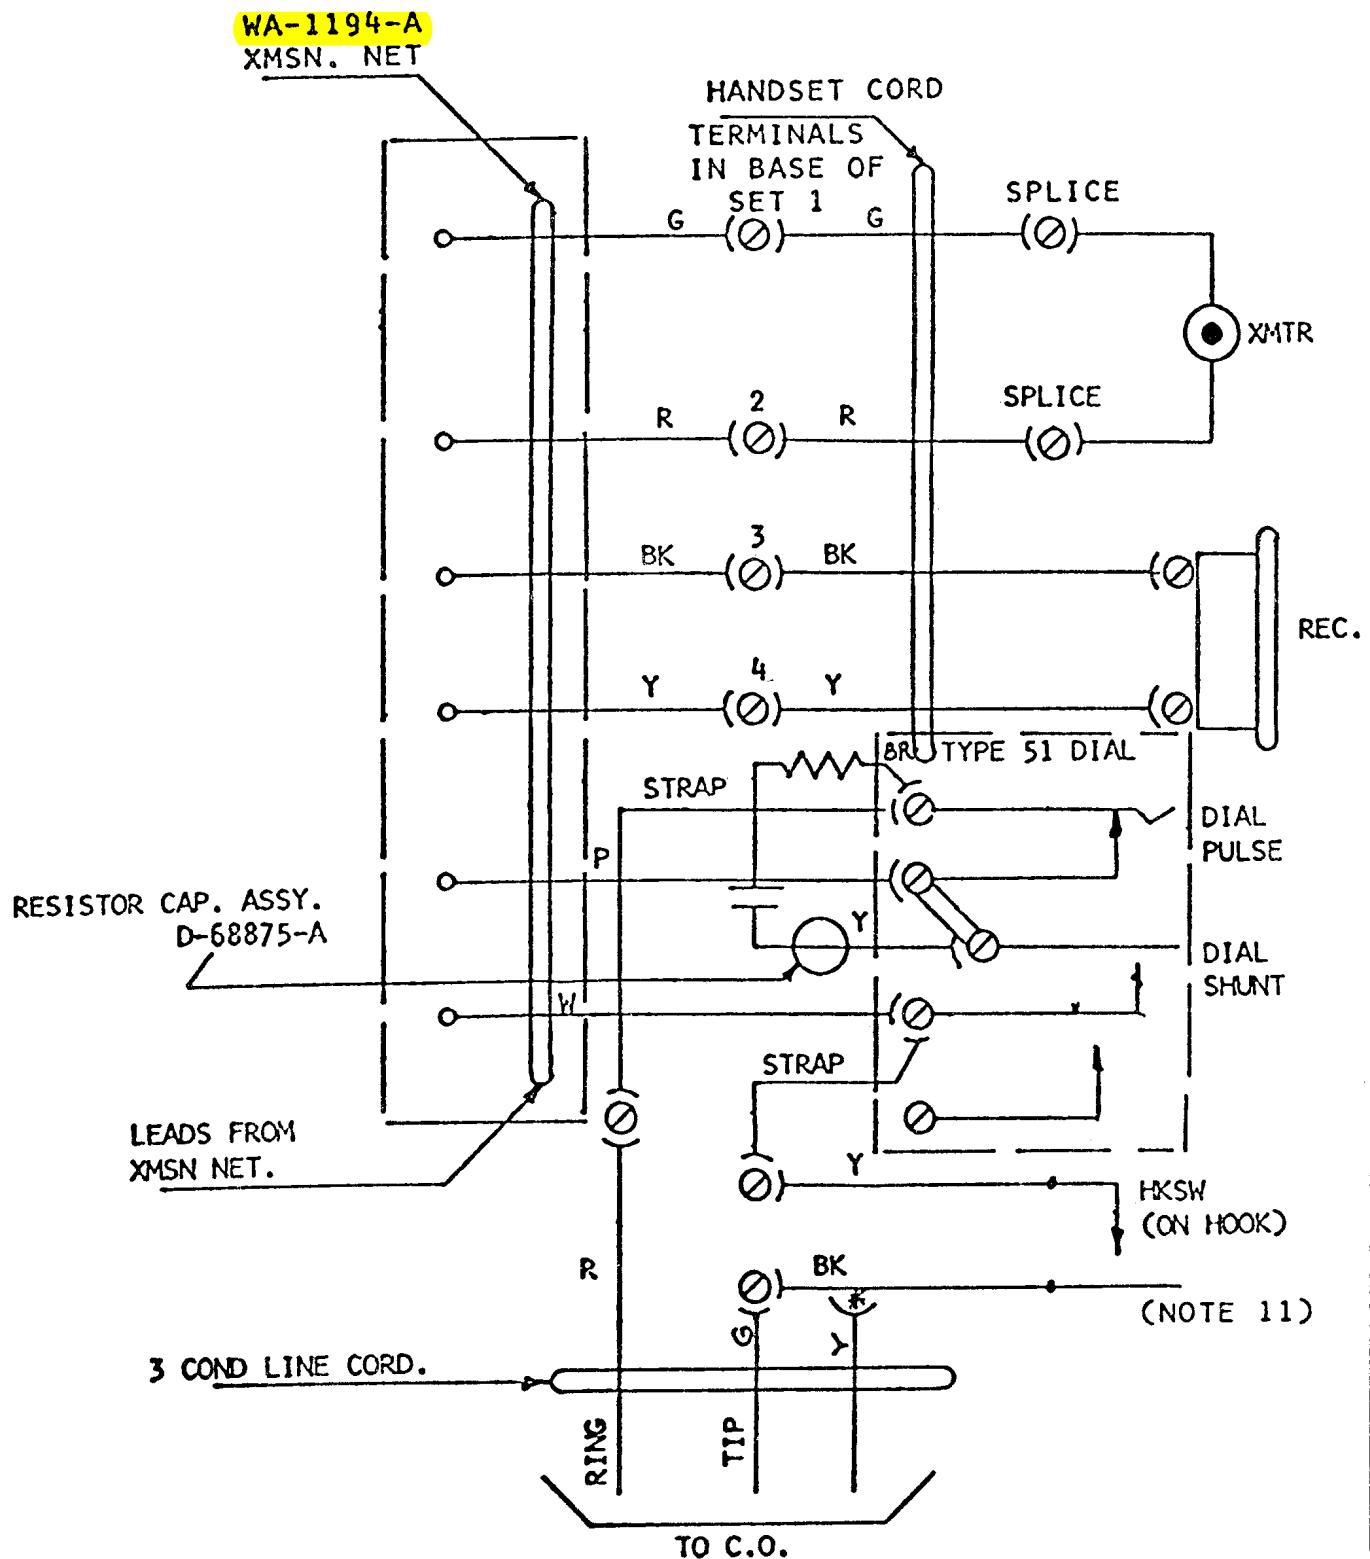


|                            |                     |      |                              |
|----------------------------|---------------------|------|------------------------------|
| FORM NO.<br>ED 0002        | DRAWN BY (Initials) | DATE | TITLE<br>FIG. 9              |
| FORM SHEET NO.<br>1 (7-73) | APP BY (Initials)   | DATE | DRAWING NO.<br>EPC-2000-FG.9 |
|                            |                     |      | SHEET NO.<br>1 OF 1          |
|                            |                     |      | ISSUE NO.<br>8               |

**GENERAL TELEPHONE OF CALIFORNIA**  
An Equal Opportunity Employer

TO COPY OR REPRODUCE THE DRAWING IN WHOLE OR IN PART, OR TO USE THE DRAWING TO REPRODUCE THE MATERIALS THEREIN, OR FOR ANY OTHER PURPOSE, WITHOUT WRITTEN PERMISSION FROM GENERAL TELEPHONE CO. OF CALIFORNIA, THIS NOTICE DOES NOT APPLY TO THE U.S. GOVERNMENT TO THE EXTENT THAT IT IS INCONSISTENT WITH ANY CONTRACT WITH THE GOVERNMENT UNDER WHICH THIS DRAWING IS DELIVERED.

FIG. 10

**3 SLOT COIN TELEPHONE (N.E. & W.E. CO.)**

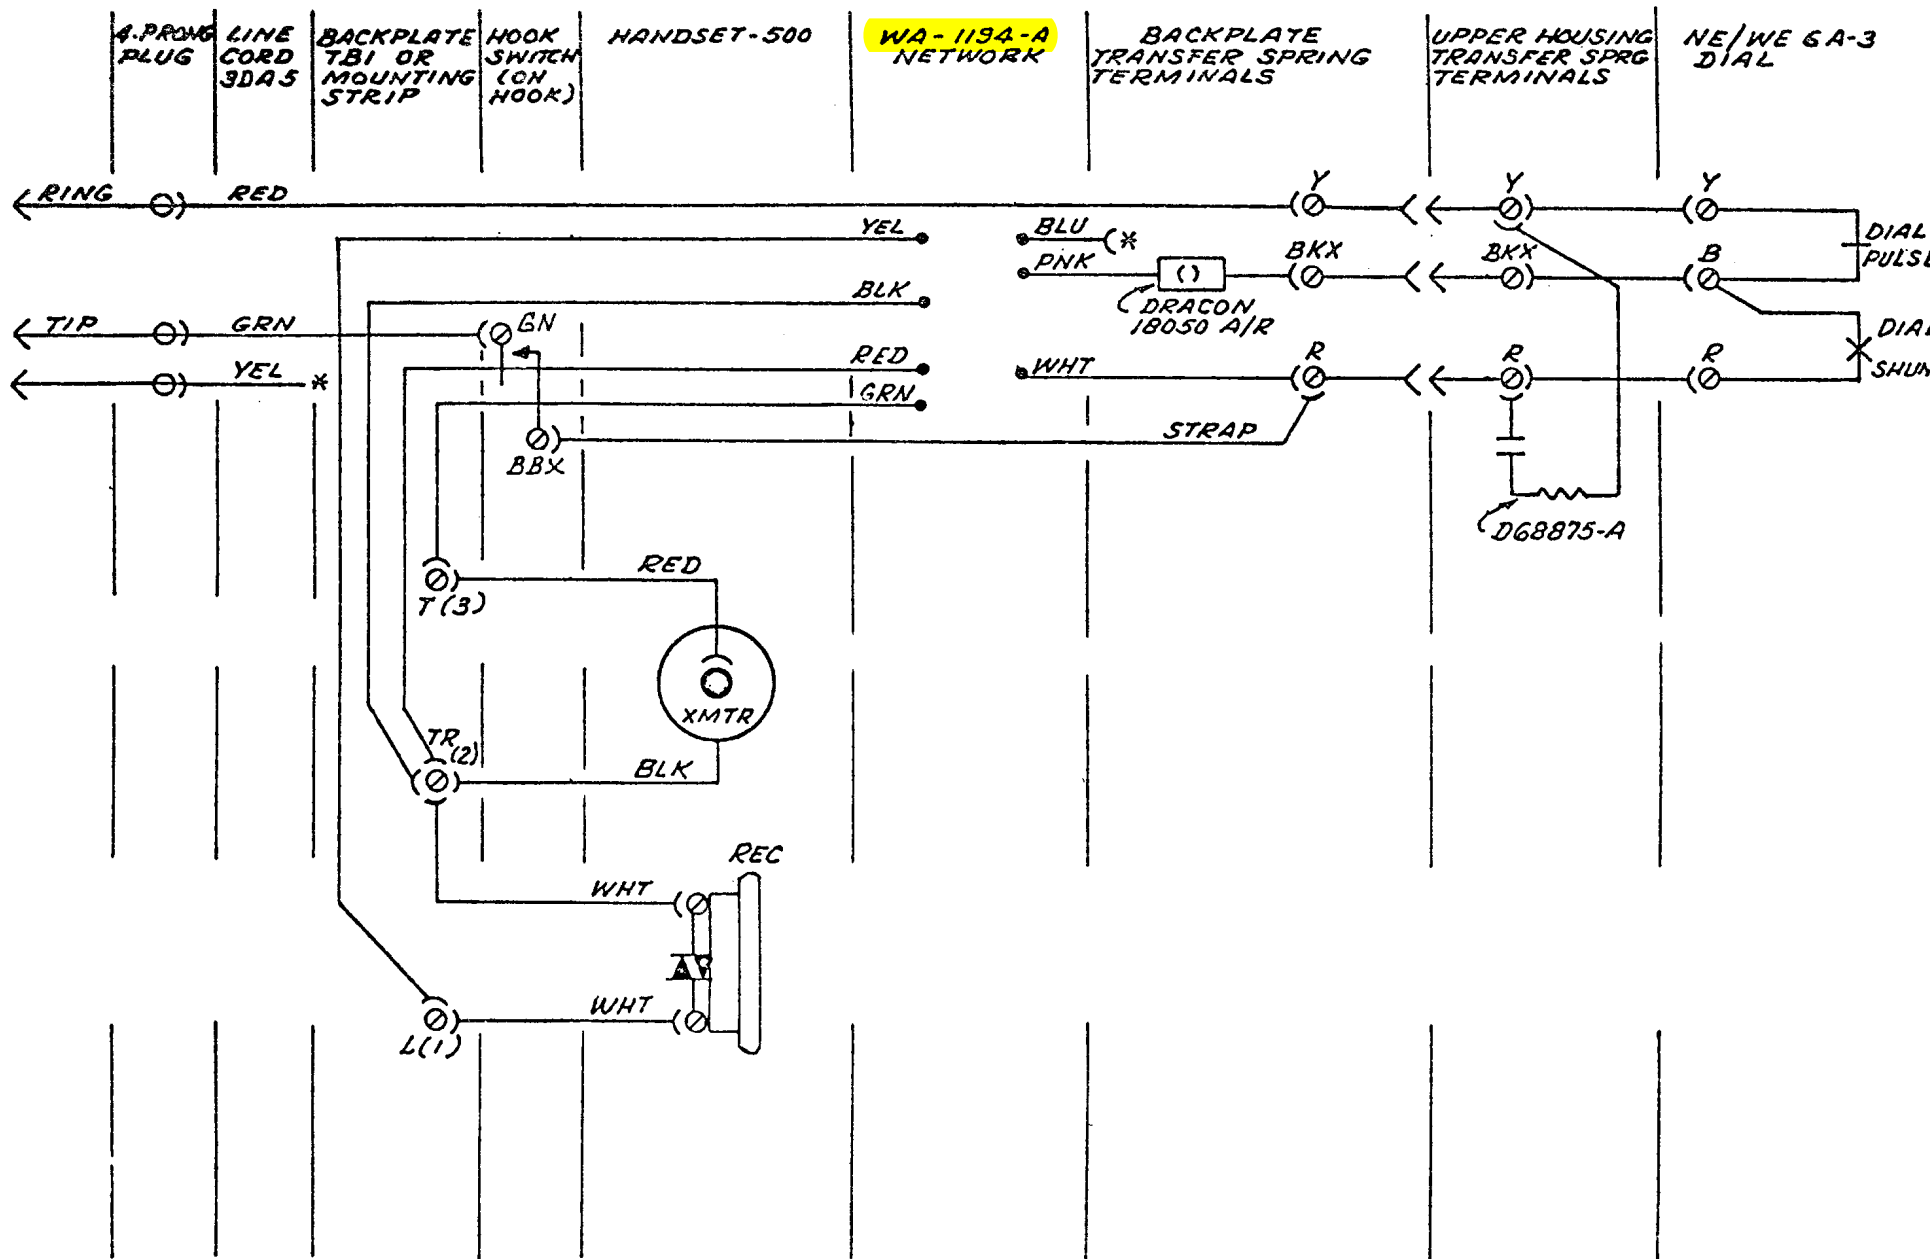


\* BOOTIE & STORE

FIG. 10

|                            |                     |                |                               |
|----------------------------|---------------------|----------------|-------------------------------|
| FORM NO.<br>ED 0002        | DRAWN BY (Initials) | DATE           | TITLE                         |
| FORM SHEET NO.<br>1 (7-73) | APP BY (Initials)   | DATE           | DRAWING NO.<br>EPC-2000-FG.10 |
| SHEET NO.<br>1 OF 1        |                     | ISSUE NO.<br>/ |                               |

**GENERAL TELEPHONE OF CALIFORNIA**  
An Equal Opportunity Employer

**FIGURE 11 (NOTE 2)**  
**WALL MAGNETO TEL. W/DIAL & RINGER (W.E., S.C. OR KELLOGG)**

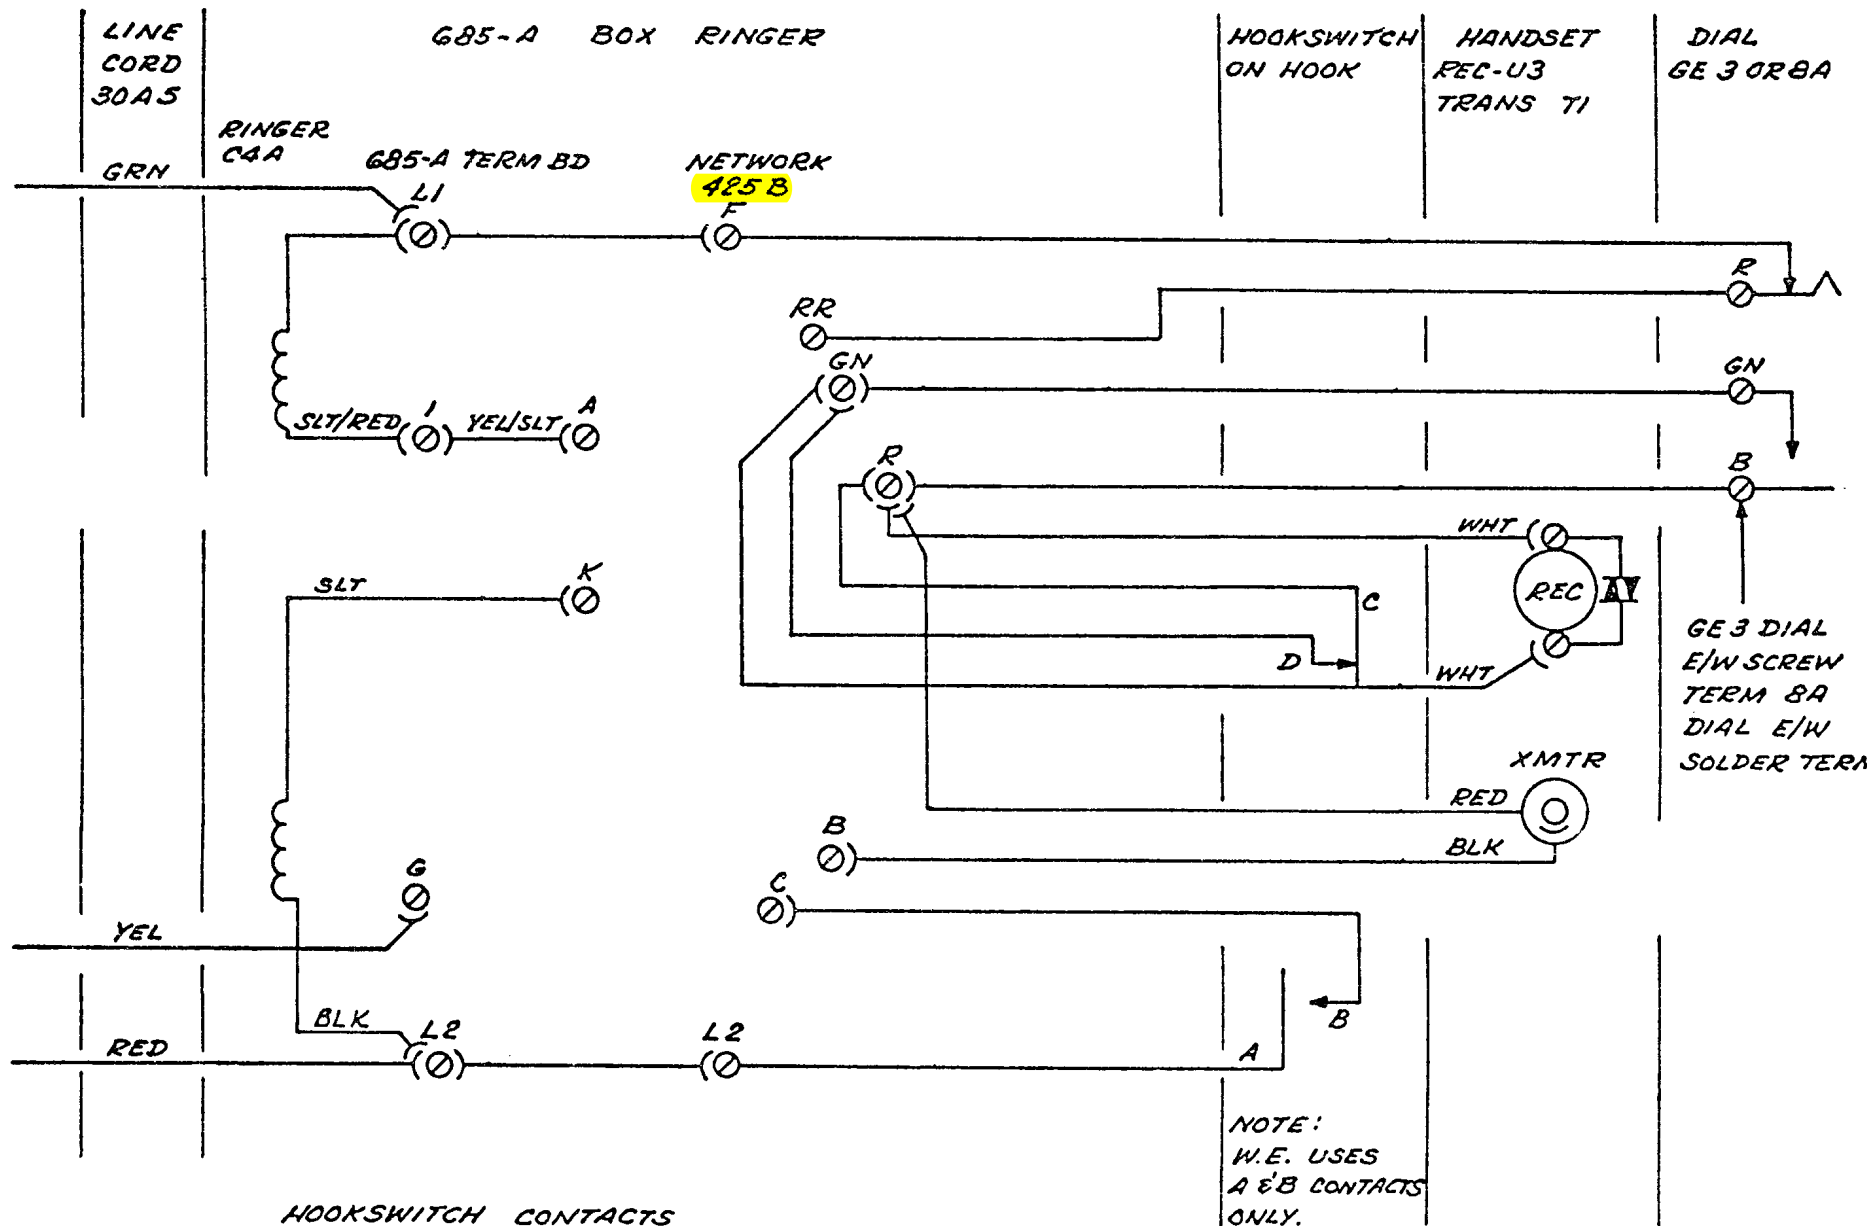

HOOKSWITCH CONTACTS  
A & B CONTACTS MAKE  
BEFORE C & D CONTACTS BREAK

FIG. 11


SHEET NO. 1 OF 1  
ISSUE NO. 1

**GENERAL TELEPHONE OF CALIFORNIA**  
An Equal Opportunity Employer

THIS DRAWING IS THE PROPERTY OF GENERAL TELEPHONE OF CALIFORNIA. IT IS TO BE USED FOR THE PURPOSES SPECIFIED HEREIN. IT IS NOT TO BE COPIED, REPRODUCED, OR FOR ANY OTHER PURPOSE, WITHOUT WRITTEN PERMISSION FROM GENERAL TELEPHONE CO. OF CALIFORNIA. THIS NOTICE DOES NOT APPLY TO THE U.S. GOVERNMENT TO THE EXTENT THAT IT IS INCONSISTENT WITH ANY CONTRACT WITH THE GOVERNMENT UNDER WHICH THIS DRAWING IS DELIVERED.

FIG. 12

**CANDLESTICK (METAL) FOLD-A-FONE INC.,**

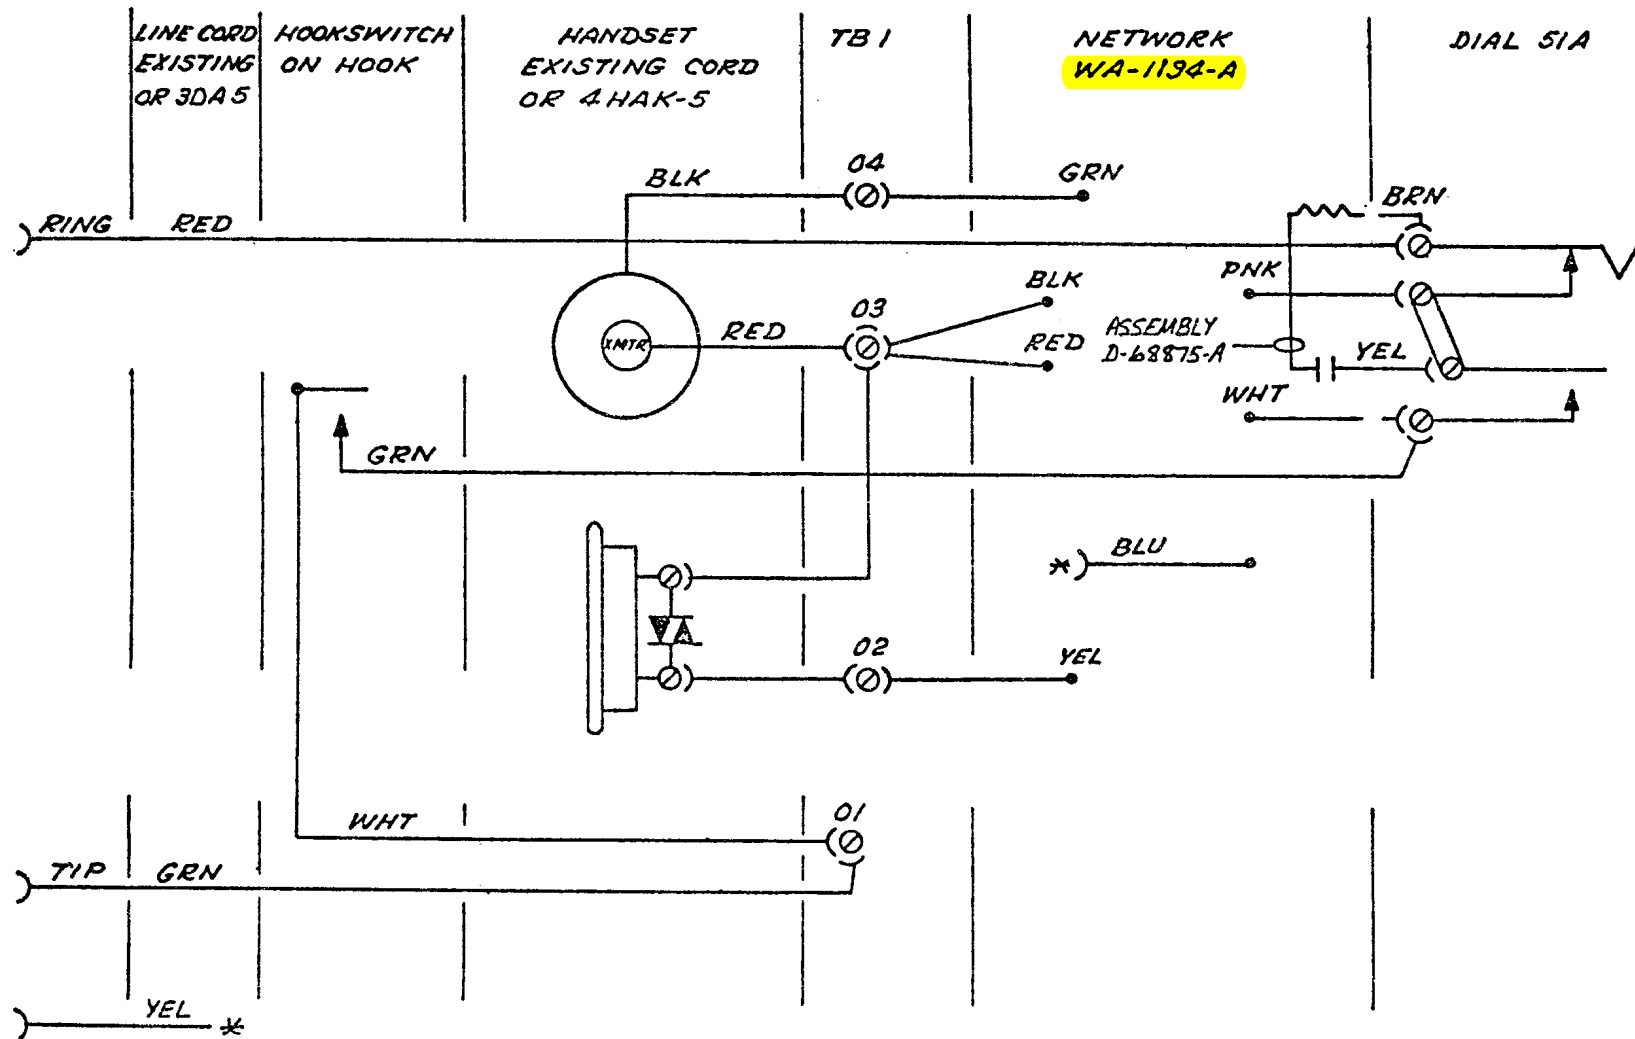

\* BOOTIE & STORE

FIG. 12

FORM NO.  
ED 0002

DRAWN BY (Initials) DATE

TITLE


DRAWING NO.

EPC-2000-FG.12

SHEET NO. 1 OF 1

FIGURE 13 (NOTE 2)

**WALL MAGNETO TEL W/T.C & RINGER (W.E., S.C., OR KELLOGG)**

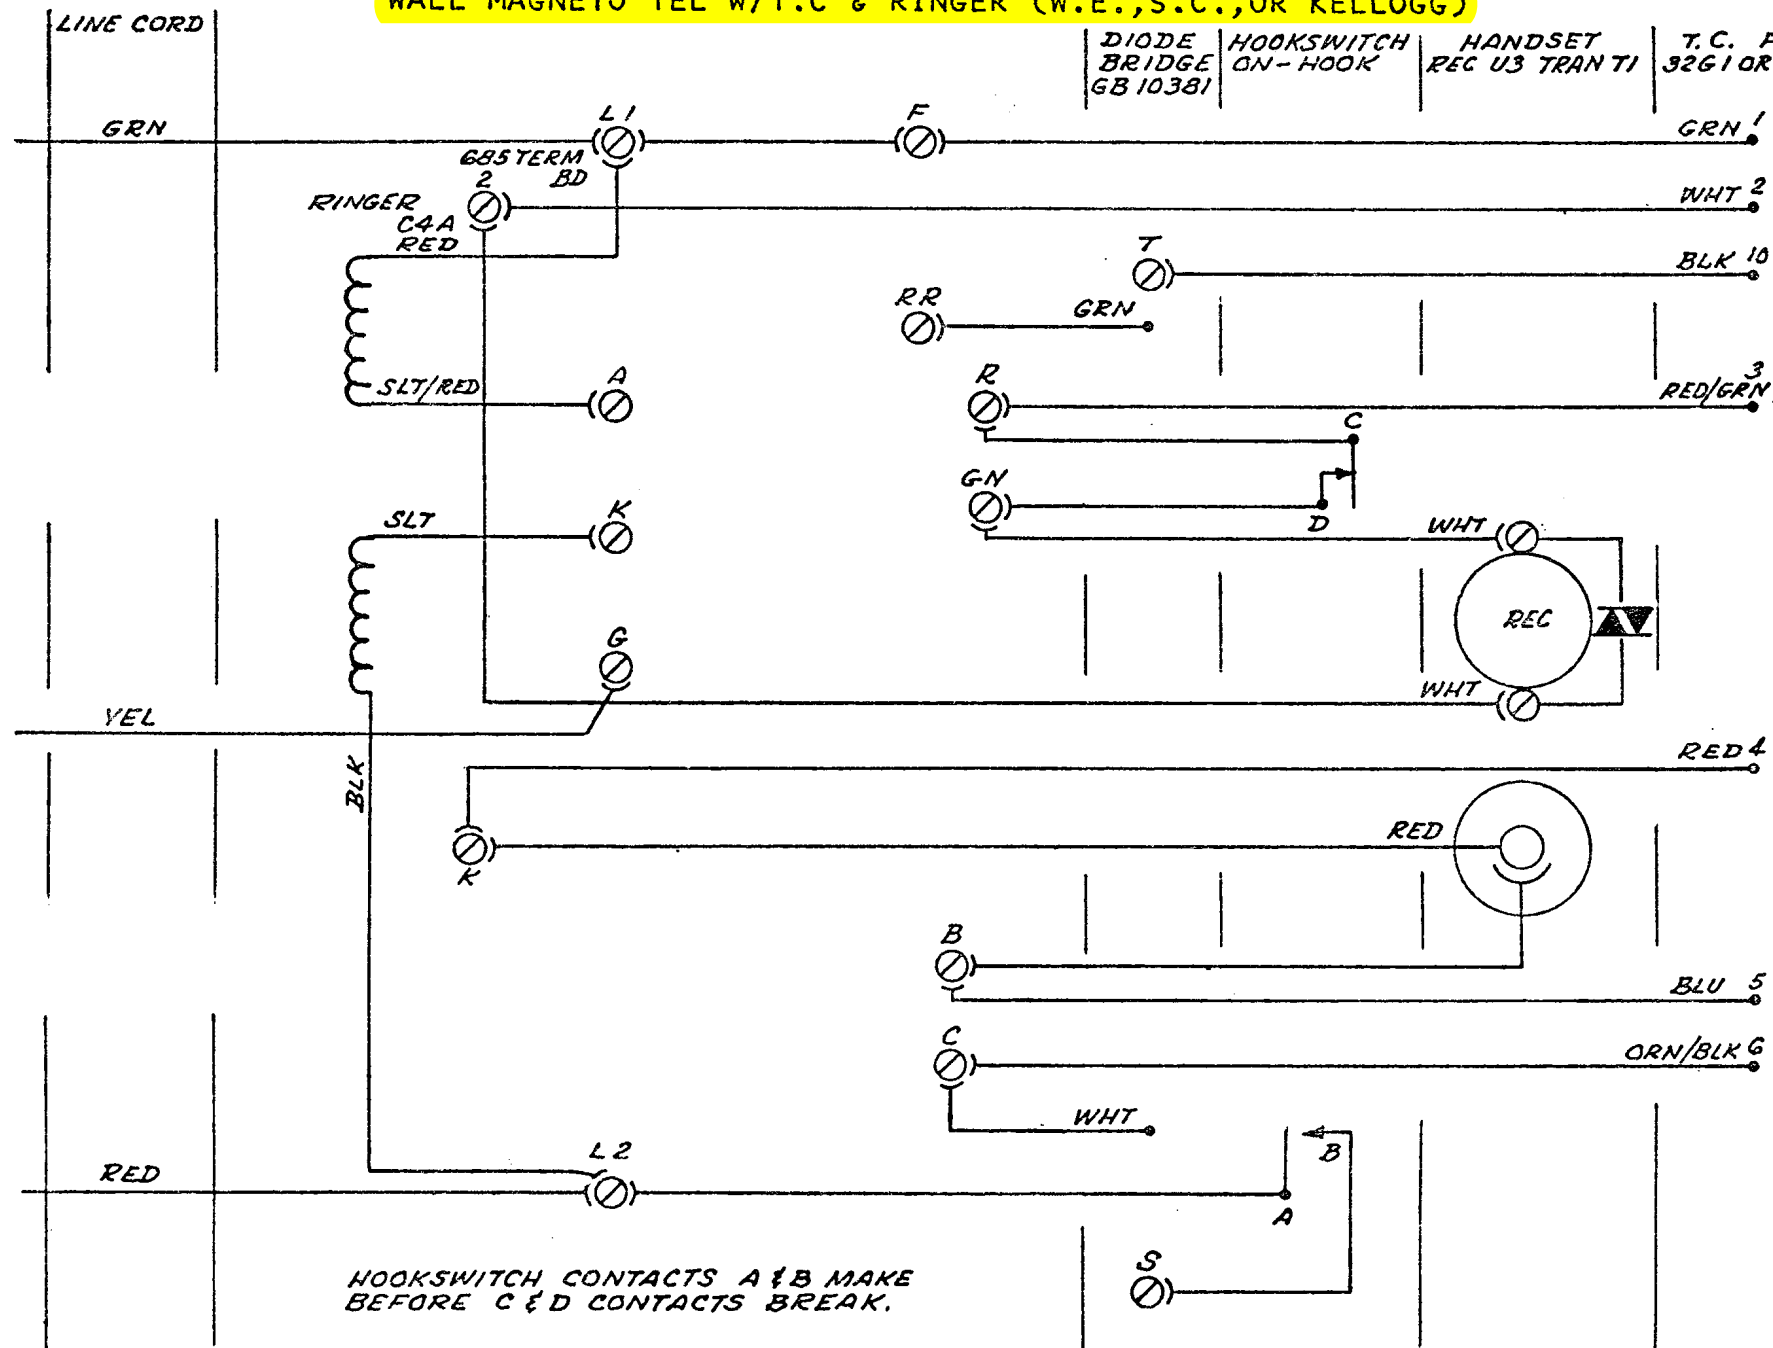


|                            |                     |                     |                               |
|----------------------------|---------------------|---------------------|-------------------------------|
| FORM NO.<br>ED 0002        | DRAWN BY (Initials) | DATE                | TITLE                         |
| FORM SHEET NO.<br>1 (7-73) | APP BY (Initials)   | DATE                | DRAWING NO.<br>EPC-2000-FG.13 |
| FIG. 13                    |                     | SHEET NO.<br>1 OF 1 |                               |
|                            |                     | ISSUE NO.           |                               |

TO COPY OR REPRODUCE THE DATA IN WHOLE OR IN PART, OR TO USE IN ANY MANNER TO REPRODUCE THE MATERIAL DESCRIBED THEREIN, WITHOUT WRITTEN PERMISSION FROM GENERAL TELEPHONE CO. OF CALIFORNIA. THIS NOTICE DOES NOT APPLY TO THE U.S. GOVERNMENT TO THE EXTENT THAT IT IS INCONSISTENT WITH ANY CONTRACT WITH THE GOVERNMENT UNDER WHICH THIS DRAWING IS DELIVERED.


TCI Library- <http://www.telephonecollectors.info/>  
**GENERAL TELEPHONE OF CALIFORNIA**  
 An Equal Opportunity Employer

FIGURE 14  
 WALL PANEL-GALAXY-GB 2750 AND CHROME FONE WIRING

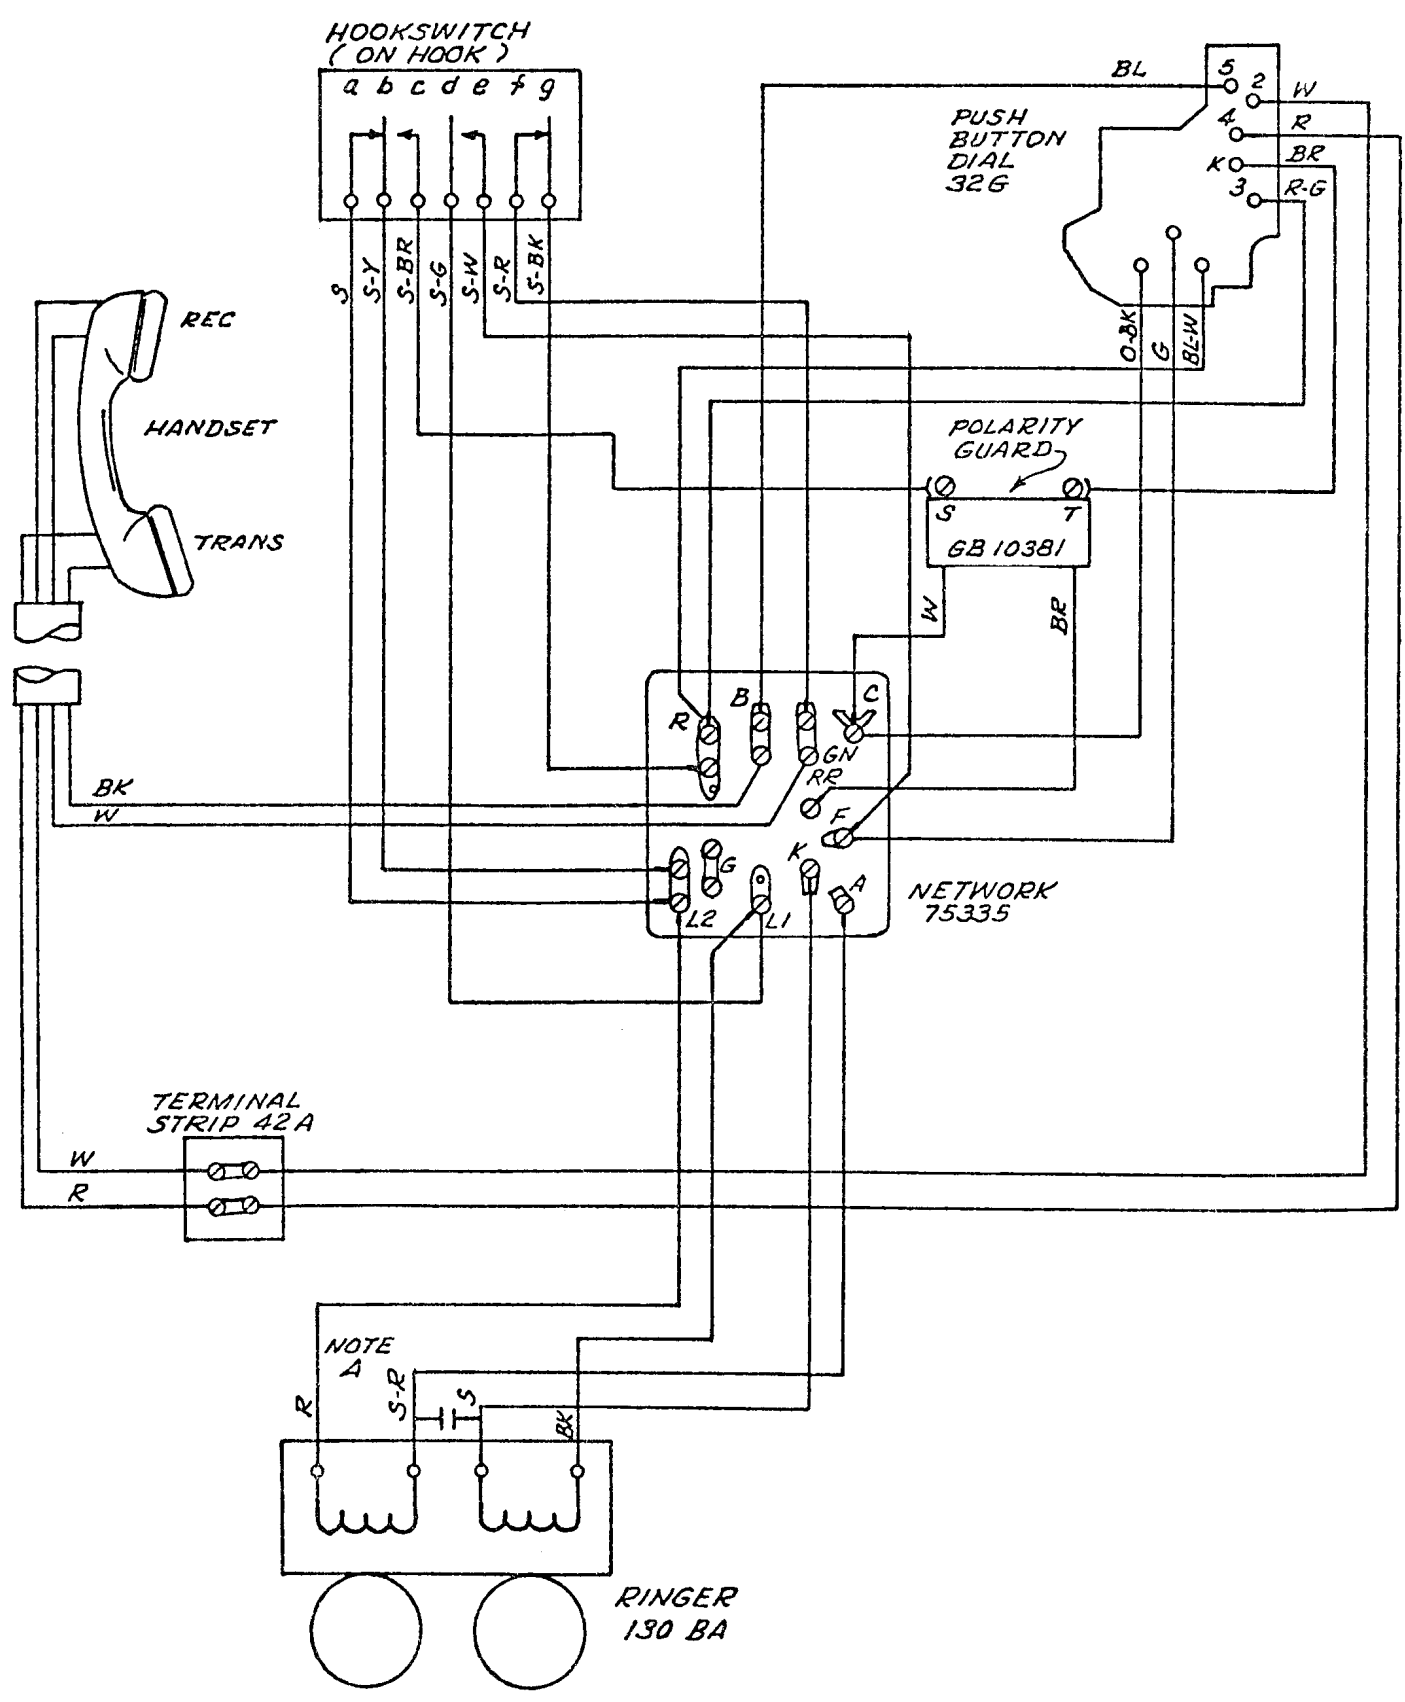

|                            |                     |      |                               |                     |           |
|----------------------------|---------------------|------|-------------------------------|---------------------|-----------|
| FORM NO.<br>ED 0002        | DRAWN BY (Initials) | DATE | TITLE<br>FIG. 14              |                     |           |
| FORM SHEET NO.<br>1 (7-73) | APP BY (Initials)   | DATE | DRAWING NO.<br>EPC-2000-FG 14 | SHEET NO.<br>1 OF 1 | ISSUE NO. |


FIGURE 15  
CANDLESTICK ATC/S.C. WIRING

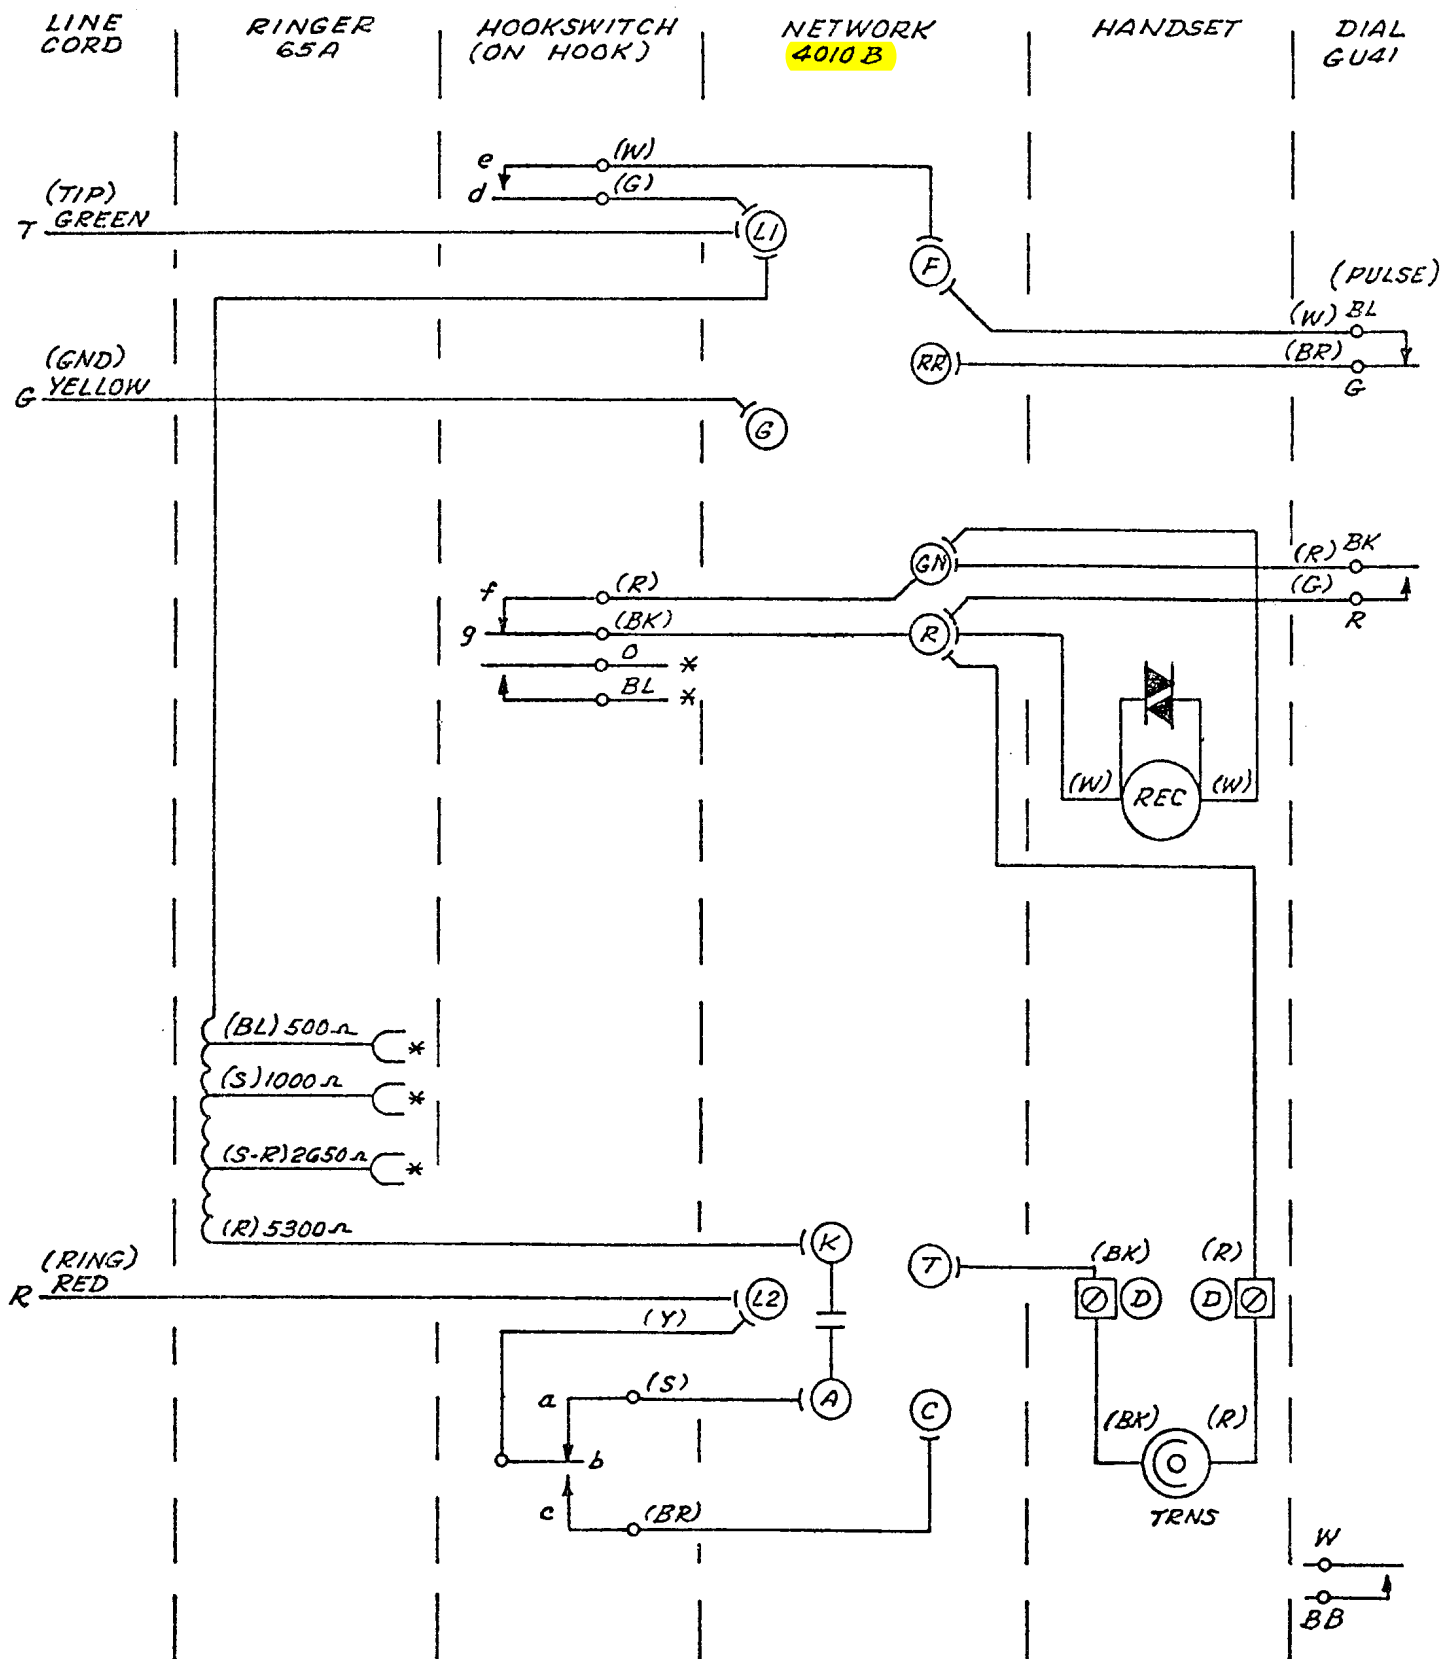

NOTE  
\* = INSULATE & STORE

|                            |                     |      |                                |                     |
|----------------------------|---------------------|------|--------------------------------|---------------------|
| FORM NO.<br>ED 0002        | DRAWN BY (Initials) | DATE | TITLE<br>FIG. 15               |                     |
| FORM SHEET NO.<br>1 (7-73) | APP BY (Initials)   | DATE | DRAWING NO.<br>EPC-2000-FG. 15 | SHEET NO.<br>1 OF 1 |
|                            |                     |      | ISSUE NO.<br>/                 |                     |

**FIGURE 16**  
**TELEPHONE W/DIAL & RINGER WIRING**

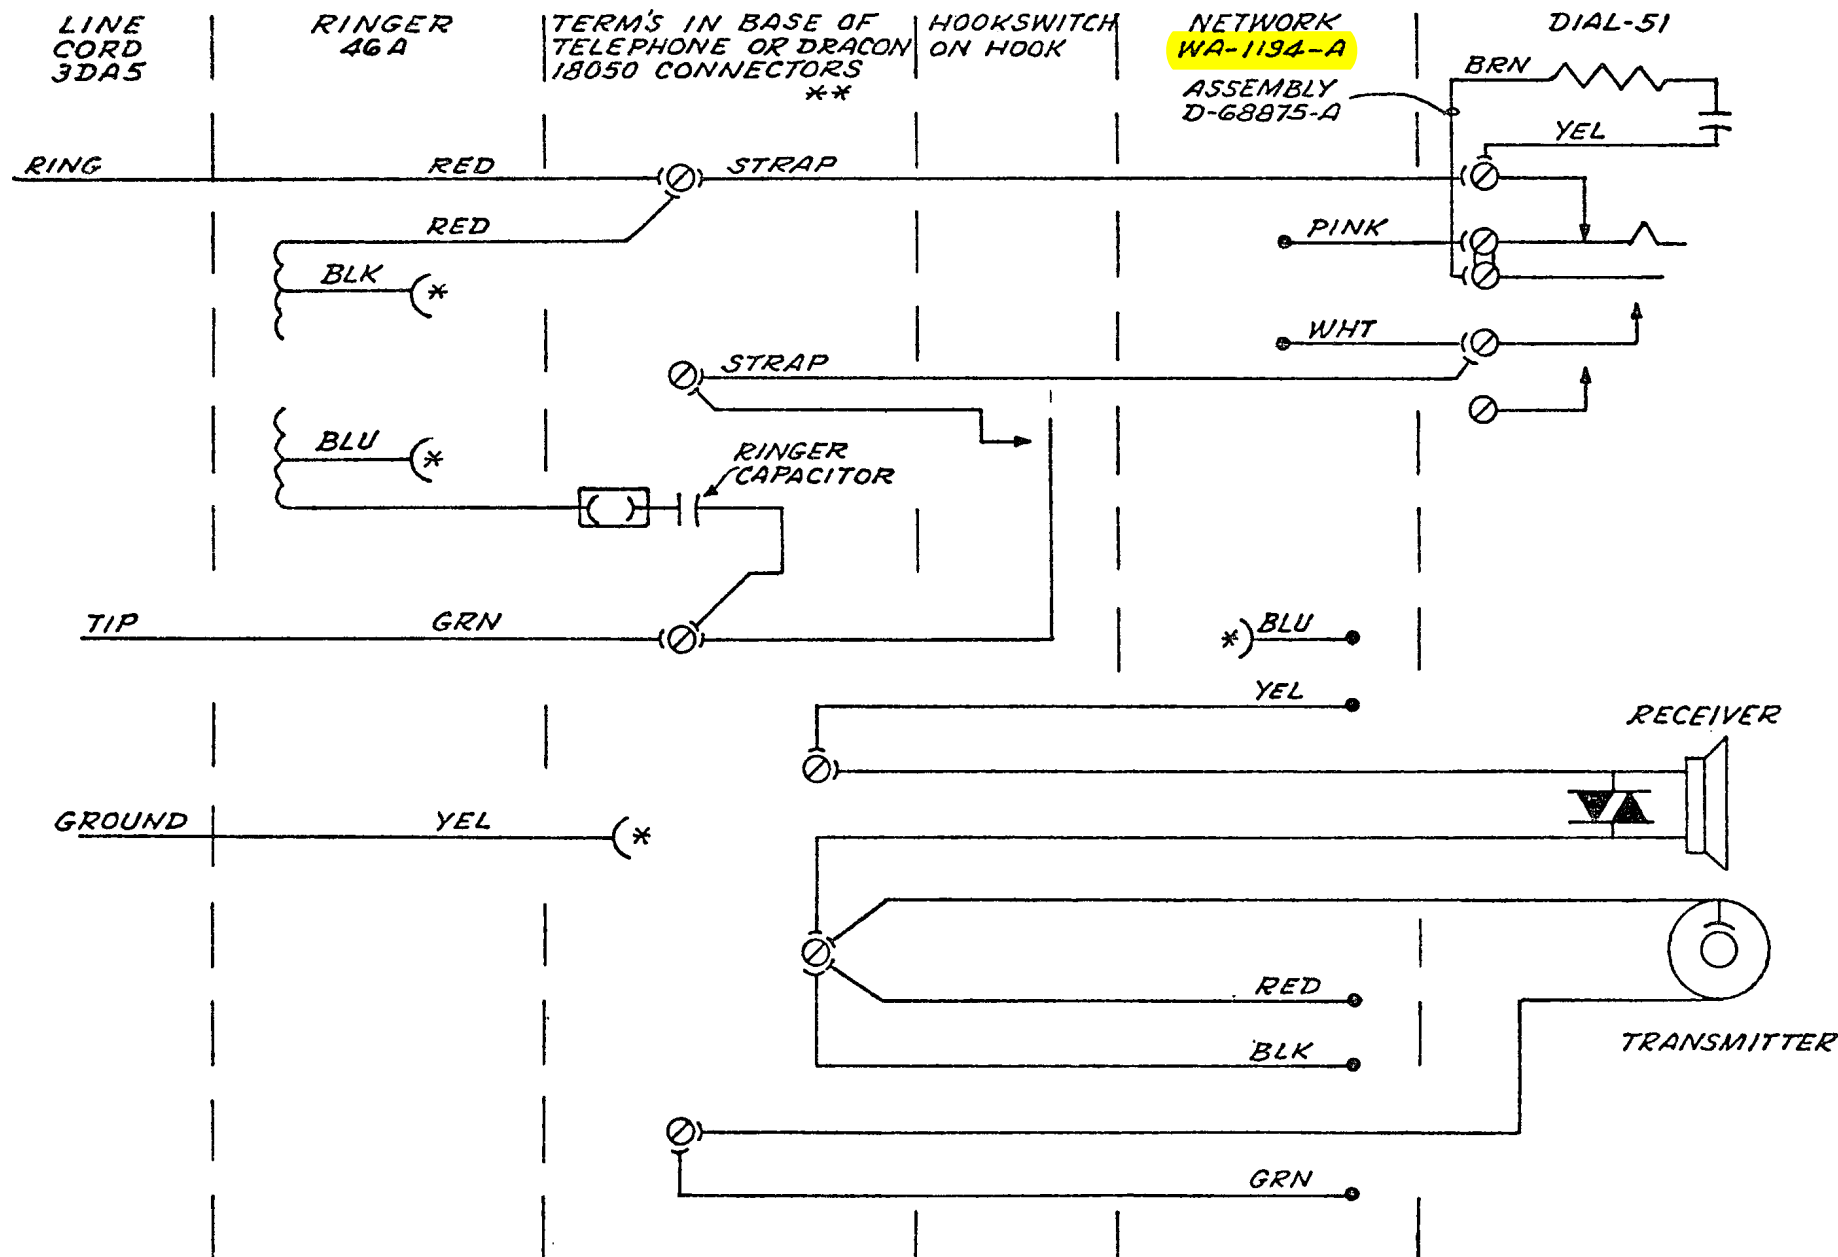


\* BOOTIE & STORE  
\*\* IN ORDER TO CONNECT MORE THAN 2 LEADS PER CONNECTOR, TERMINATE 2 LEADS PER SPADE.

|                            |                     |           |                               |
|----------------------------|---------------------|-----------|-------------------------------|
| FORM NO.<br>ED 0002        | DRAWN BY (Initials) | DATE      | TITLE<br>FIG. 16              |
| FORM SHEET NO.<br>1 (7-73) | APP BY (Initials)   | DATE      | DRAWING NO.<br>EPC-2000-FG 16 |
| SHEET NO.<br>1 OF 1        |                     | ISSUE NO. |                               |

**GENERAL TELEPHONE OF CALIFORNIA**  
An Equal Opportunity Employer

TO COPY OR REPRODUCE THE DRAWING IN WHOLE OR IN PART, OR TO USE THE DRAWING TO REPRODUCE THE MATERIAL OR FOR ANY OTHER PURPOSE, WITHOUT WRITTEN PERMISSION FROM GENERAL TELEPHONE CO. OF CALIFORNIA. THIS NOTICE DOES NOT APPLY TO THE U.S. GOVERNMENT TO THE EXTENT THAT IT IS INCONSISTENT WITH ANY CONTRACT WITH THE GOVERNMENT UNDER WHICH THIS DRAWING IS DELIVERED.

**FIGURE 17**  
**TELEPHONE LESS DIAL & W/RINGER WIRING**

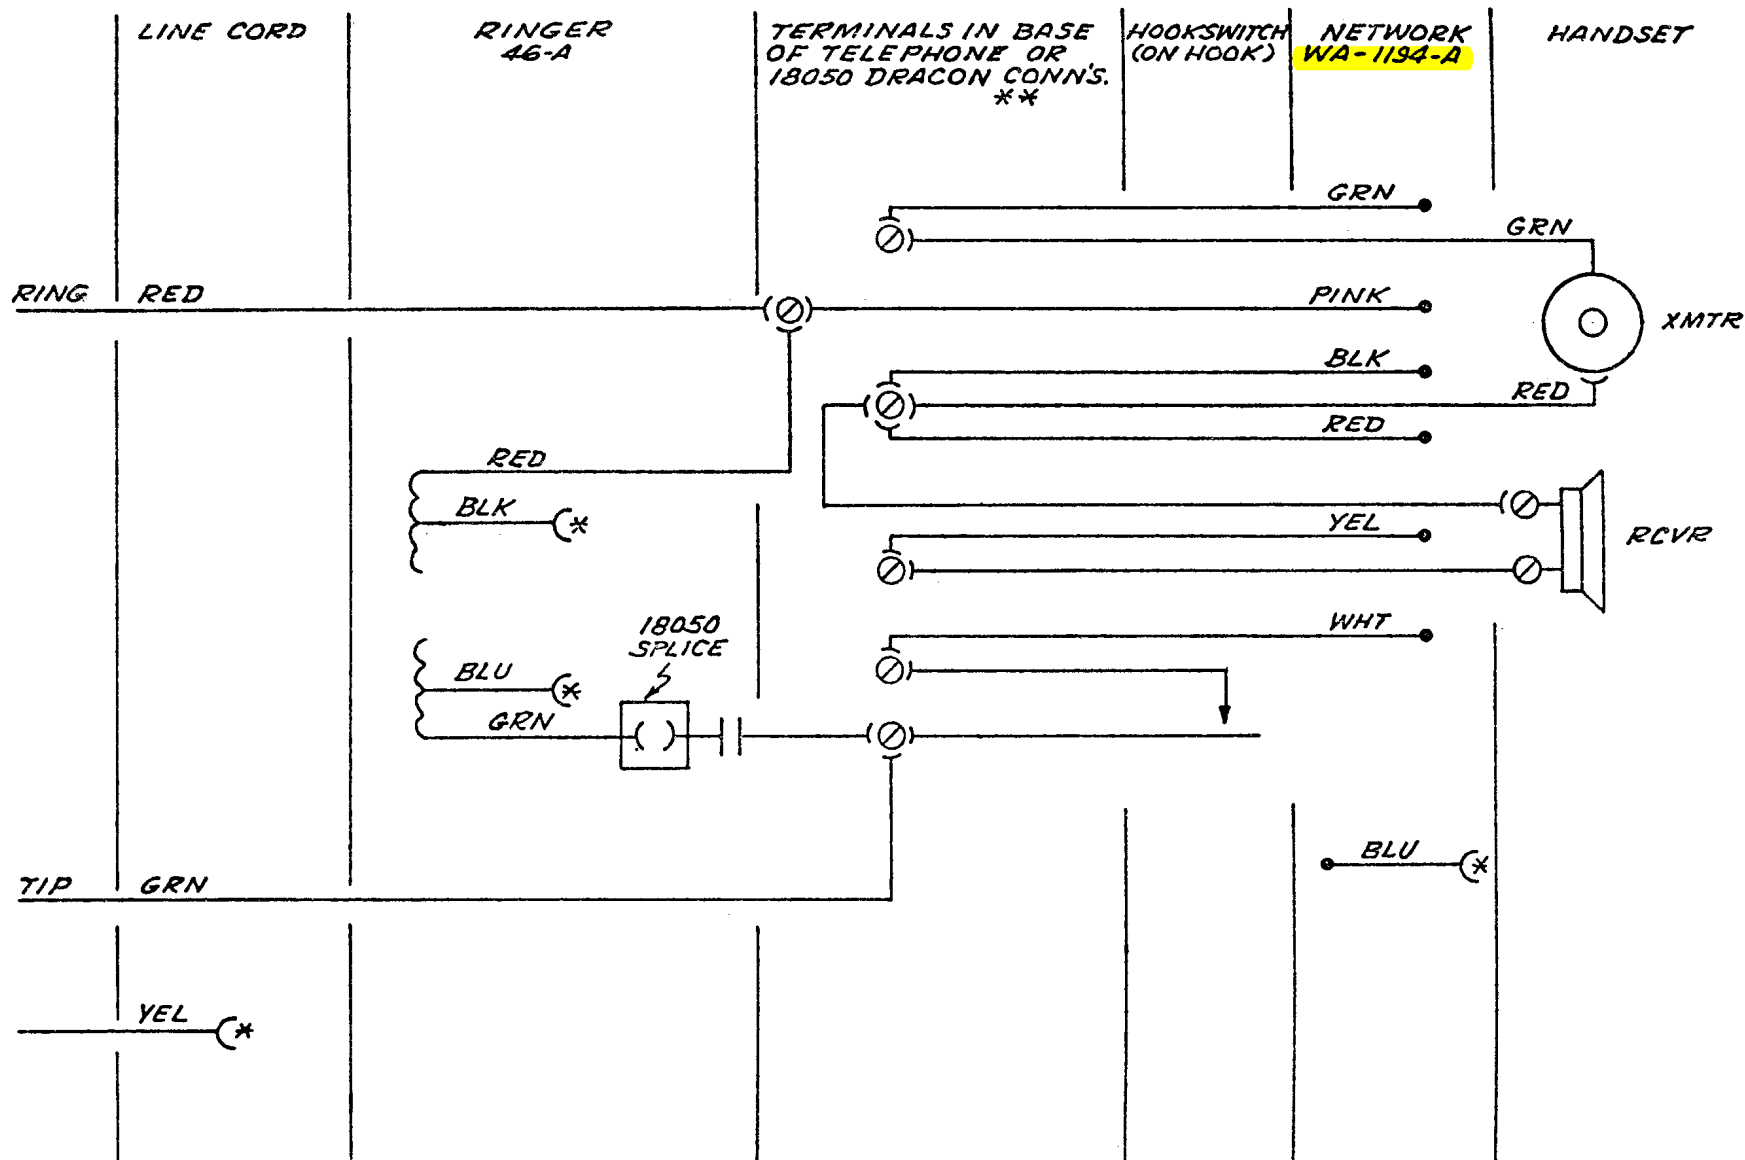

\* BOOTIE & STORE  
\*\* IN ORDER TO CONNECT MORE THAN 2 LEADS  
PER CONNECTOR, TERMINATE 2 LEADS PER SPADE.

|                            |                     |      |                               |
|----------------------------|---------------------|------|-------------------------------|
| FORM NO.<br>ED 0002        | DRAWN BY (Initials) | DATE | TITLE                         |
| FORM SHEET NO.<br>1 (7-73) | APP BY (Initials)   | DATE | DRAWING NO.<br>EPC-2000-FG 17 |
| FIG. 17                    |                     |      |                               |
| SHEET NO. 1 OF 1           |                     |      |                               |

**FIGURE 18**  
**EMPRESS ATC/AE WIRING**

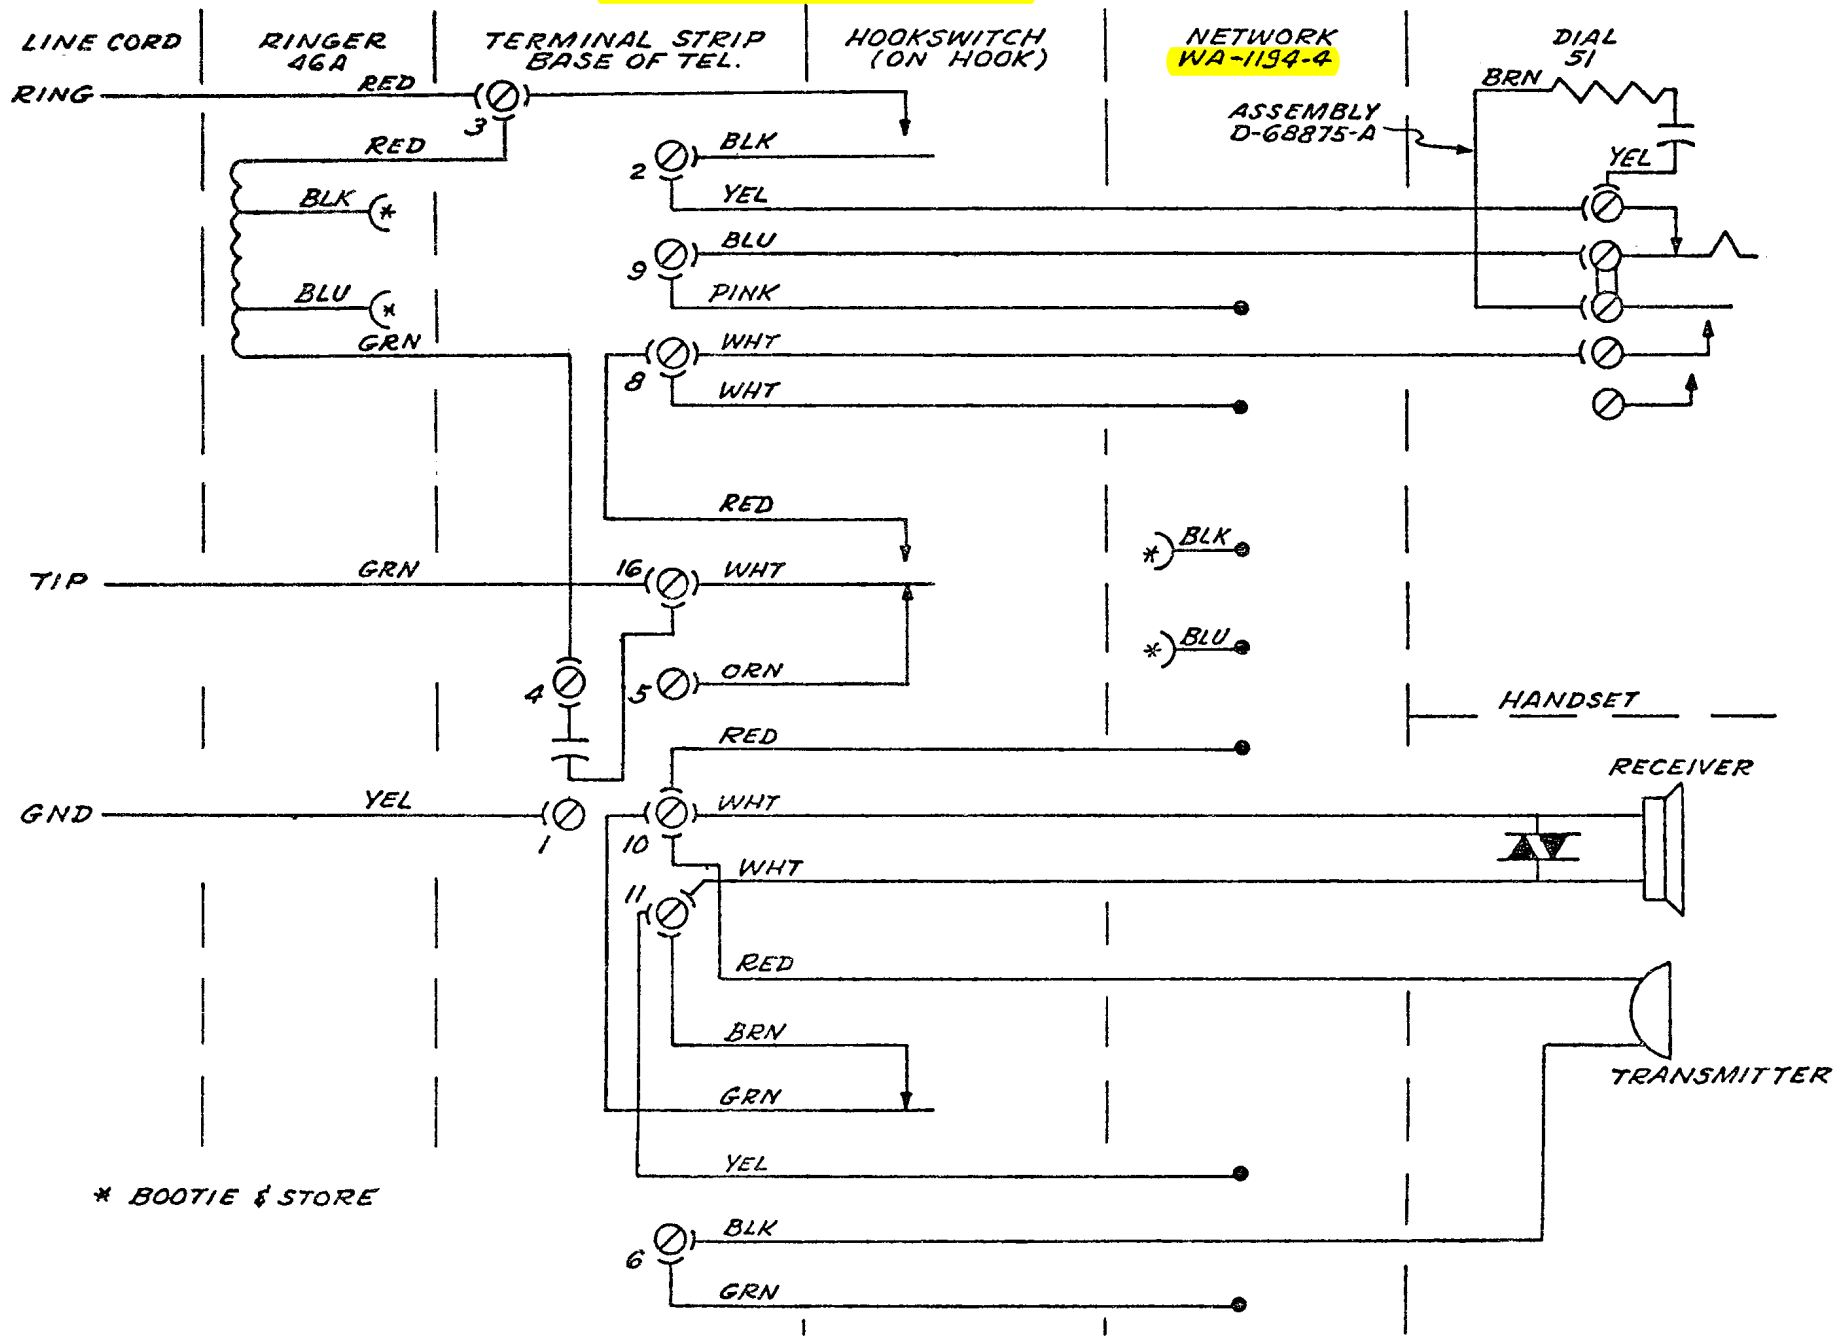


FIG. 18


|                            |                     |           |                               |
|----------------------------|---------------------|-----------|-------------------------------|
| FORM NO.<br>ED0002         | DRAWN BY (Initials) | DATE      | TITLE                         |
| FORM SHEET NO.<br>1 (7-73) | APP BY (Initials)   | DATE      | DRAWING NO.<br>EPC-2000-FG 18 |
| SHEET NO.<br>1 OF 1        |                     | ISSUE NO. |                               |

THIS DRAWING IS THE PROPERTY OF GENERAL TELEPHONE CO. OF CALIFORNIA. ITS USE IS LIMITED TO THE PROJECT FOR WHICH IT WAS PREPARED. NO PART OF THIS DRAWING IS TO BE REPRODUCED OR COPIED IN ANY MANNER OR FOR ANY OTHER PURPOSE, WITHOUT WRITTEN PERMISSION FROM GENERAL TELEPHONE CO. OF CALIFORNIA. THIS NOTICE DOES NOT APPLY TO THE U.S. GOVERNMENT TO THE EXTENT THAT IT IS INCONSISTENT WITH ANY CONTRACT WITH THE GOVERNMENT UNDER WHICH THIS DRAWING IS DELIVERED.

GENERAL TELEPHONE CO. OF CALIFORNIA  
An Equal Opportunity Employer

TCL Library- <http://www.telephon collectors.info/>

FIGURE 19  
EMPRESS ATC/SC/NE/WE & CHROMEPHONE WIRING

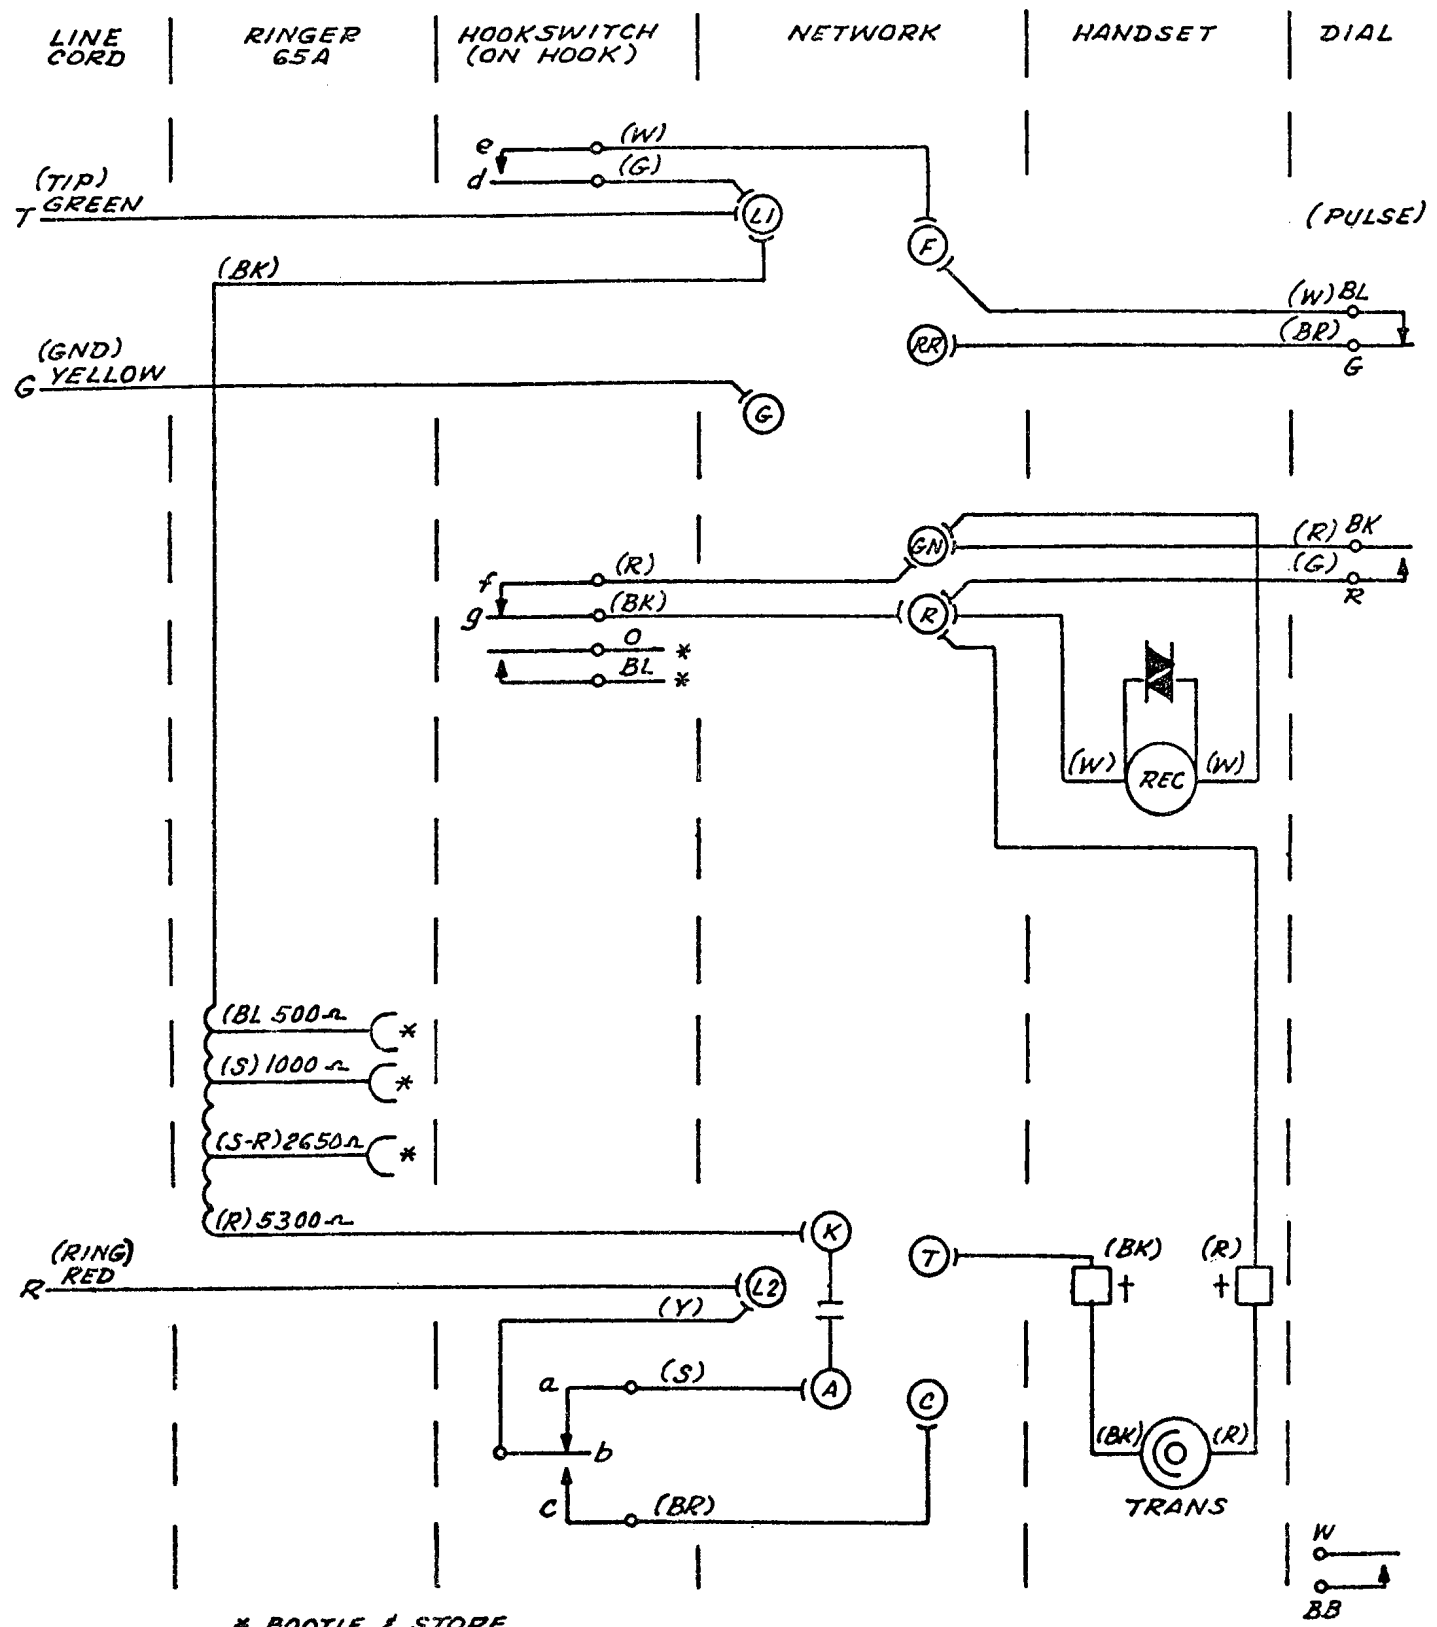

\* BOOTIE & STORE

NOTES:  
1. TELEPHONES MANUFACTURED BY TELE CONCEPTS (CLEAR PLASTIC) HAVE EXTRA WIRES FOR APPEARANCE ONLY & FUNCTIONAL WIRING COLOR CODE MAY VARY FROM WIRING DIAGRAM.

|                            |                     |      |                                |                     |
|----------------------------|---------------------|------|--------------------------------|---------------------|
| FORM NO.<br>ED 0002        | DRAWN BY (Initials) | DATE | TITLE<br>FIG. 19               |                     |
| FORM SHEET NO.<br>1 (7-73) | APP BY (Initials)   | DATE | DRAWING NO.<br>EPC-2000-FG. 19 | SHEET NO.<br>1 OF 1 |
|                            |                     |      | ISSUE NO.<br>/                 |                     |